


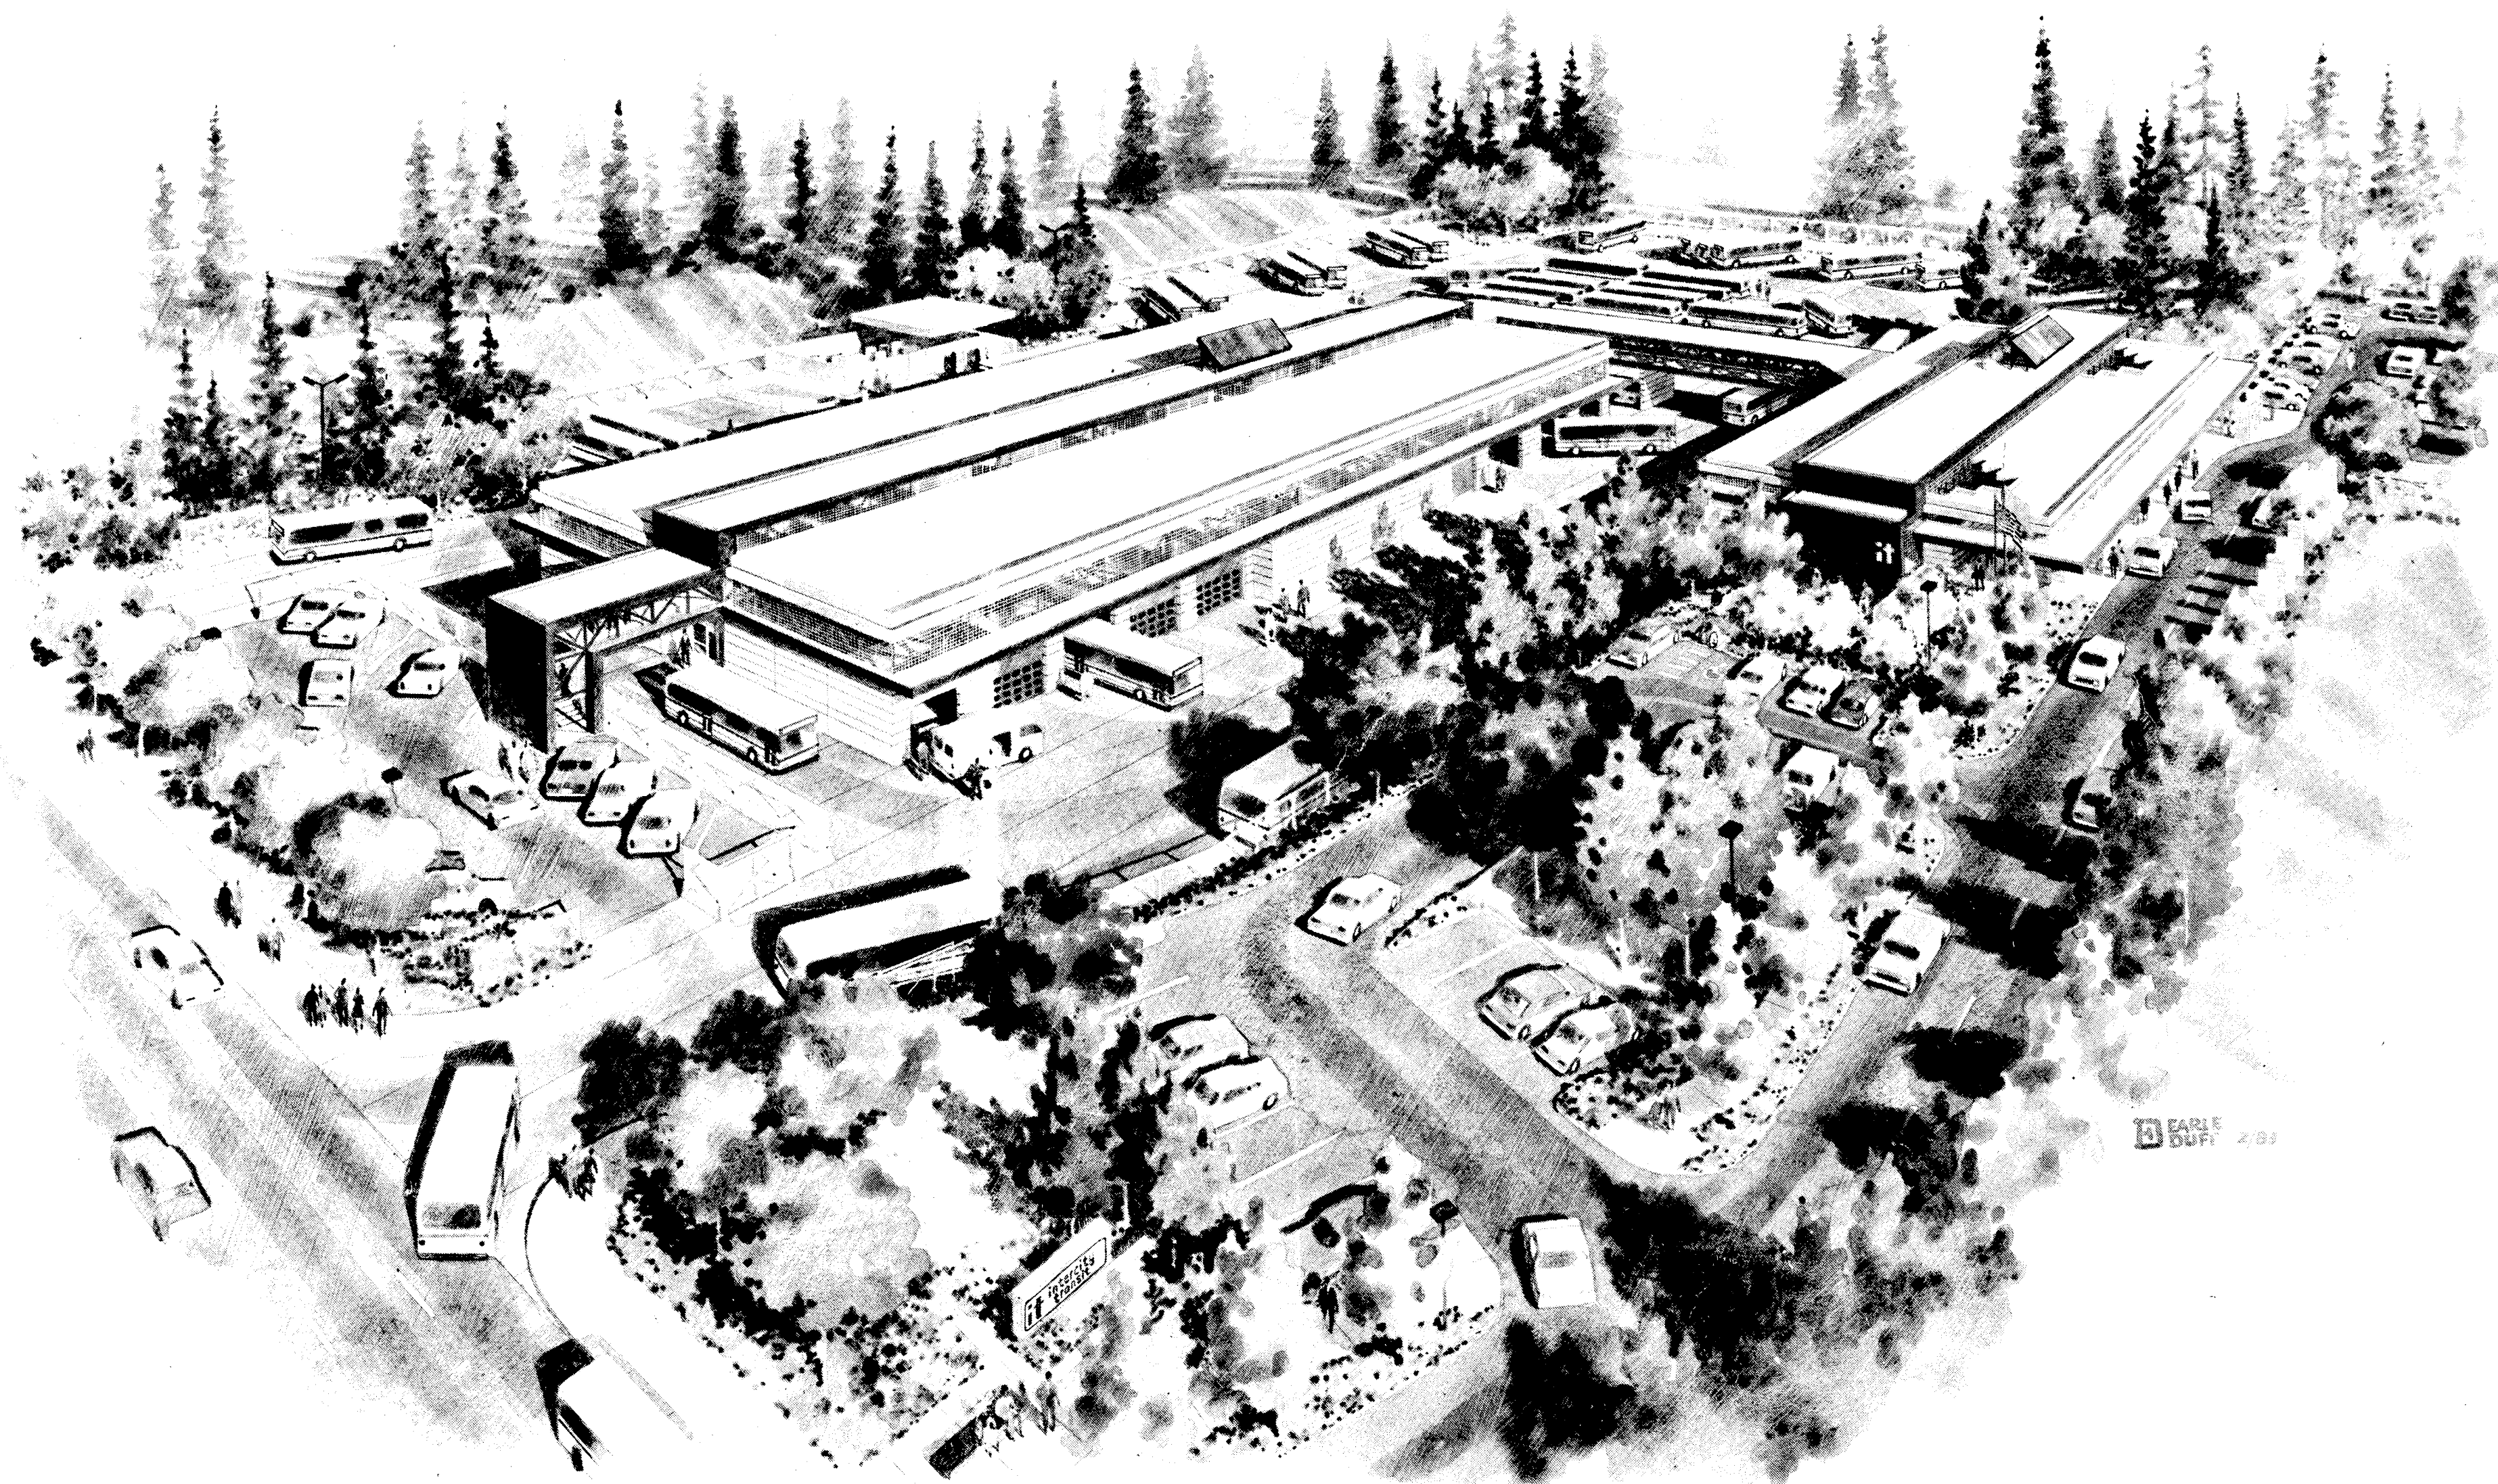

Intercity Transit Authority
Mark O. Brown
Gilbert J. Carbone
George Barner
Philip H. Schmidt

Chairman, Lacey
 Vice-Chairman, Olympia
 Thurston County
 Tumwater

General Manager
James H. Slakey

Asst. General Manager, Project Coordinator
Roger A. Dean
 (206) 753-8107

Architects, M/E Engineers
Tsang Merritt Associates
 (206) 383-1987

Associate Architect
LeRoy John Pardini, Architect A.I.A.
 (206) 786-1906

Transit Systems Consultant
Fleet Maintenance Consultants, Inc.
 (713) 496-7717

Structural Engineer
ABAM Engineers, Inc.
 (206) 952-6100

Energy Systems
Sol Arc
 (415) 548-7327


Civil Engineer
R. D. Blinn, Consulting Engineer
 (206) 754-3993

Landscape Architect
K. Frank Kirkbride & Associates
 (206) 491-6900

Acoustics Consultant
Dynac Sciences
 (206) 564-3286

INDEX TO DRAWINGS

ARCHITECTURAL	
A0.1	Cover Sheet
A1.1	Site Plan Dimensions
A1.2	Site Plan Contours
A2.1	Maintenance Building Floor Plan, Lower Level, West Portion
A2.2	Maintenance Building Floor Plan, Upper Level, West Portion
A2.3	Maintenance Building Floor Plan, Lower & Upper Level, East Portion
A2.4	Operations/Administration Building Floor Plan
A2.5	Bridge Floor Plan, Elevations & Sections
A3.1	Maintenance Building North & West Exterior Elevations
A3.2	Maintenance Building South & East Exterior Elevations
A3.3	Operations/Administration Building Exterior Elevations
A3.4	Maintenance Building, Building Sections
A3.5	Maintenance Building, Building Sections
A3.6	Operations/Administration Building, Building Sections
A3.7	Maintenance Building, Building Sections
A4.1	Maintenance Building Large Scale Plans
A4.2	Operations/Administration Building Large Scale Plans
A5.1	Maintenance Building Interior Elevations
A5.2	Maintenance Building Interior Elevations
A5.3	Maintenance Building Interior Elevations
A5.4	Maintenance Building Interior Elevations
A5.5	Maintenance Building Interior Elevations
A5.6	Maintenance Building Interior Elevations
A5.7	Operations/Administration Building Interior Elevations
A5.8	Operations/Administration Building Interior Elevations
A5.9	Operations/Administration Building Interior Elevations
A5.10	Operations/Administration Building Interior Elevations
A6.1	Maintenance Building Lower Level Reflected Ceiling Plan, West Portion
A6.2	Maintenance Building Upper Level Reflected Ceiling Plan, West Portion
A6.3	Maintenance Building Lower & Upper Reflected Ceiling Plan, East Portion
A6.4	Operations/Administration Building Lower & Upper Level Reflected Ceiling Plans
A7.1	Maintenance Building Vertical Circulation
A7.2	Operations/Administration Building Vertical Circulation
A8.1	Maintenance Building Wall Sections
A8.2	Maintenance Building Wall Sections
A8.3	Operations/Administration Building Wall Sections
A8.4	Operations/Administration Building Wall Sections
STRUCTURAL	
S2.1	Maintenance Building Foundation & Lower Level Slab Plan, West Portion
S2.2	Maintenance Building Upper Level Framing Plan, West Portion
S2.3	Maintenance Building Roof Framing Plan, West Portion
S2.4	Maintenance Building Foundation & Lower Level Slab Plan, East Portion
S2.5	Maintenance Building Upper Level Framing Plan and Roof Framing Plan, East Portion
S2.6	Operations/Administration Building Foundation & Lower Level Slab Plan
S2.7	Operations/Administration Building Upper Level Plan & Lunch Room Level Plan
S2.8	Operations/Administration Building Roof Framing Plan
S3.1	Maintenance Building Framing Elevations
S3.2	Maintenance Building Framing Elevations
S5.1	Truss Elevations
S5.2	Truss Elevations
S5.3	Truss Elevations
S5.4	Truss Elevations
S7.1	Stair Framing Plans
MECHANICAL	
M2.1	Site Service Plan
M2.2	Pool Plan
M2.3	Inspection Pit, Mechanical & Electrical Maintenance Building
M2.4	Motor Lists
M2.5	Motor Lists
M2.6	Foundation Level Plans, Maintenance Building, West Portion
M2.7	Heating & Ventilation, Maintenance Building, Lower Level Plan, West Portion
M2.8	Heating & Ventilation, Maintenance Building, Upper Level Plan, West Portion
M2.9	Maintenance Building, Upper Level Piping Plan, West Portion
M2.10	Maintenance Building Foundation Plan, East Portion
M2.11	Maintenance Building, Upper & Lower Plan, H & V Mechanical, East Portion
M2.12	Maintenance Building, Upper Level Piping Plan, East Portion
M2.13	Operations/Administration Foundation Piping Plan
M2.14	Operations/Administration Plumbing Plan
M2.15	Operations/Administration HVAC Plan
M3.1	Large Scale HVAC Sections
M3.2	Plumbing Sanitary Waste & Vent Piping Diagram, Maintenance Building, West & East Portions
M3.3	Plumbing Sanitary Waste & Vent Piping Diagram, Maintenance Building, West & East Portion
M3.4	Plumbing Domestic Water Piping Diagram, Maintenance Building
M3.5	Plumbing Process Water Piping Diagram, Maintenance Building
M3.6	Boiler & Water Heating Piping Schematics & Details, Maintenance Building
M4.1	Maintenance Building Plumbing Groups
M4.2	Operations/Administration Plumbing Groups
M4.3	Maintenance Building Tank Farm Plan & Details
M5.1	Mechanical Schedules & Details
M5.2	Mechanical Schedules
M6.1	Sprinkler Plan
M6.2	Sprinkler Plan
ELECTRICAL	
E2.1	Maintenance Building Lower Level Power Plan, West Portion
E2.2	Maintenance Building Lower Level Lighting Plan, West Portion
E2.3	Maintenance Building Upper Level Power Plan, West Portion
E2.4	Maintenance Building Upper Level Lighting Plan, West Portion
E2.5	Maintenance Building Lower & Upper Level Power Plan, East Portion
E2.6	Maintenance Building Lower & Upper Level Lighting Plan, East Portion
E2.7	Operations/Administration Power Plan
E2.8	Operations/Administration Lighting Plan
E2.9	Bridge Lower & Upper Level, Outdoor Storage Power & Lighting
E3.1	Distribution Diagrams & Details
E3.2	Diesel Oil/Gasoline Dispenser & Fuel Mgmt. Conduit Diagram
E4.1	Maintenance Building Interior Elevation, Wireload Application
E5.1	Schedules
E5.2	Electric Legend & Device Schedule
E5.3	Load Schedule
E6.1	General Wiring - Code Requirements
CIVIL	
C1.1	Water and Sanitary Sewer
C1.2	Stormwater Drainage & Storage
C1.3	Pavements
LANDSCAPING	
L1.1	Landscape Plan
L1.2	Irrigation Plan
L1.3	Irrigation Detail Areas
TOOLS, EQUIPMENT, AND FURNISHINGS	
T2.1	Maintenance Building Equipment Layout, West Portion
T2.2	Maintenance Building Equipment Layout, East Portion
SCHEDULE OF SUPPLEMENTARY DRAWINGS 18-1/2" x 11"	
See Book 1.	

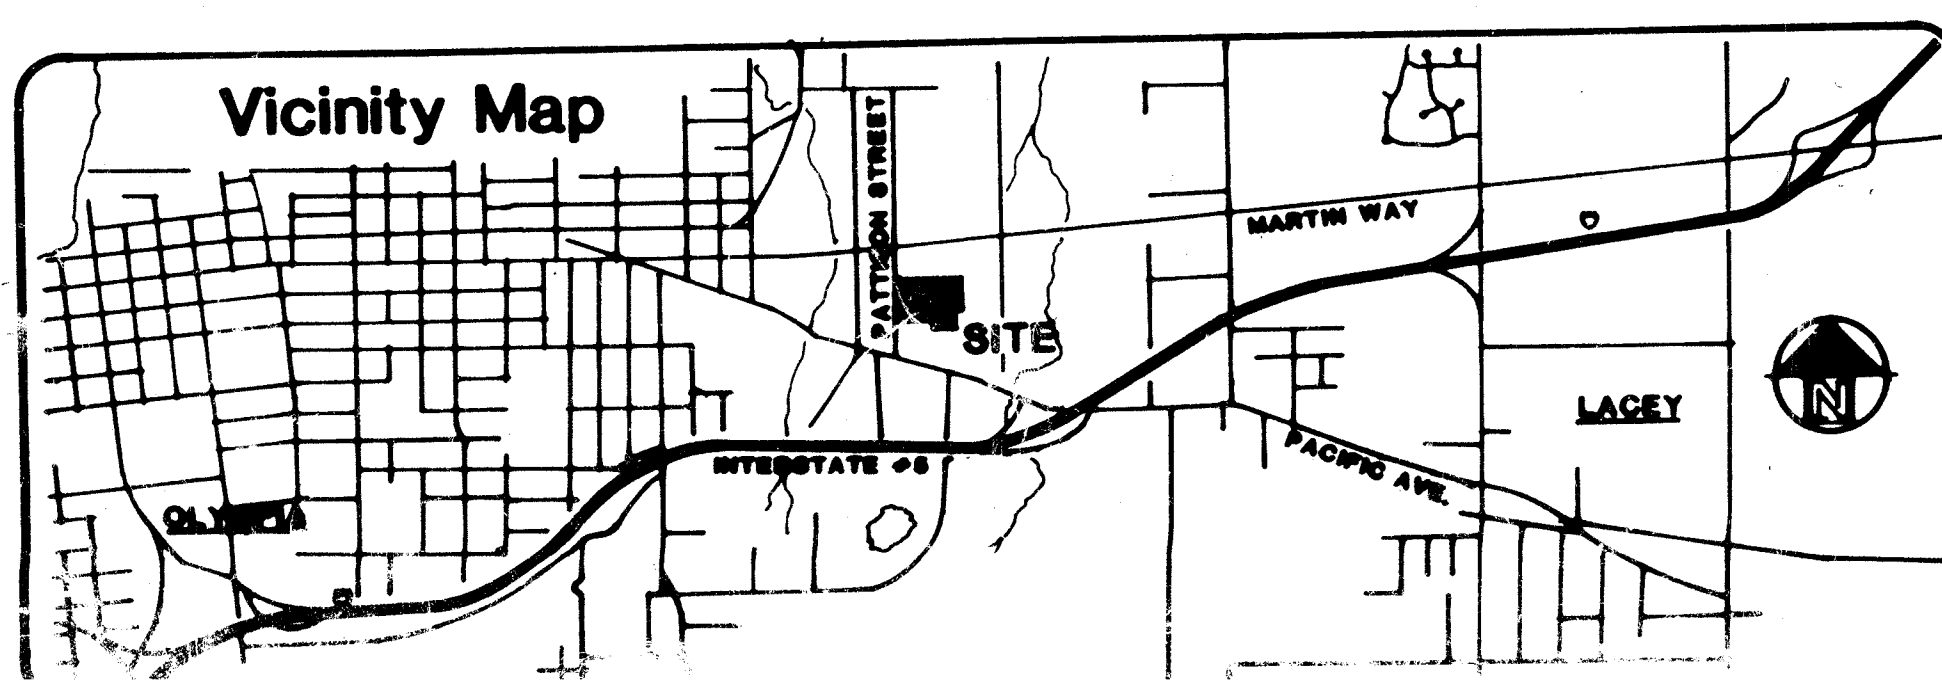

Design Criteria

APPLICABLE CODES
 A. Buildings: UBC 1979 (ICBO)
 B. Zoning: City of Olympia, 1982
 C. Others:
 1. Adoptive Ordinances for construction and development.
 2. City of Olympia (Ordinances #4201 et al.)
 3. WSDM (1981)
 4. U.P.C. (1979) Plumbing
 5. U.P.C. (1978) Fire
 6. Washington State Energy Code (1980)
 7. Federal Glazing Regulations
 8. C.E.A. Accessibility Standards (1980)

ZONING
 A. Zone: General Commercial (Chapter 18.26) C-1
 B. Fire Zone: 3 (City of Olympia)

ALLOWABLE AREAS/OCCUPANCY
 A. Type of Construction: III-N
 B. Occupancy Types:
 H-4: Maintenance (Repair garage)
 B-1: Service Base (Fueling etc.)
 B-2: Offices (Administration/Operations Building)
AREAS
 A. Site: 6.6 acres (±)
 B. Outside Stairs: 2320 S.F. (±)
 C. Maintenance Building: 42376 S.F. (±)
 D. Operations Administration Building: 14455 S.F. (±)
 E. Bridge and Exterior Stairs: 1800 S.F. (±)



Tsang Merritt Associates



Architecture
 Engineering
 Planning

1701 Commerce
 Tacoma
 Washington
 98402-3207

206
 383-1987



Members of
 the American
 Institute of
 Architects

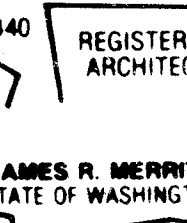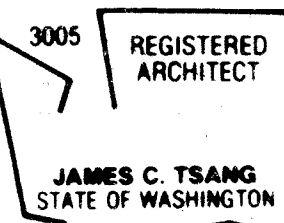

INTERCITY TRANSIT

526 South Pattison Street
 Olympia, Washington


TRANSIT
 MAINTENANCE
 OPERATIONS
 ADMINISTRATION
 FACILITY

Sheet Contents

COVER SHEET

TMA 5781
 Project Number Date 5/1/89

ACI

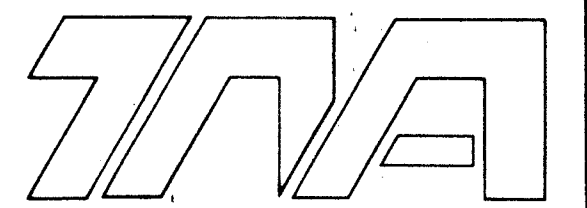

**Tsang
Merritt
Associates**




**Architecture
Engineering
Planning**

1701 Commerce
Tacoma
Washington
98402-3207

206
383-1987



Members of
the American
Institute of
Architects

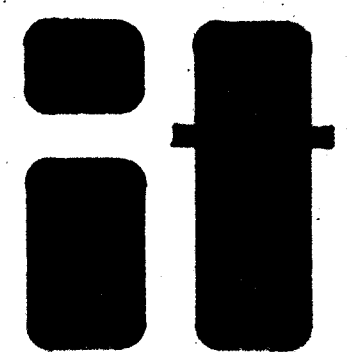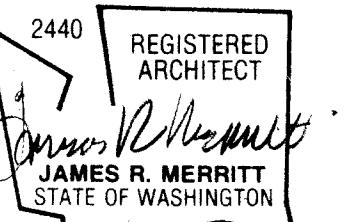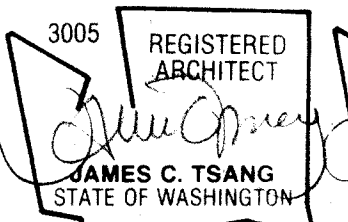

INTERCITY TRANSIT

526 South Pattison Street
Olympia, Washington

**TRANSIT
MAINTENANCE
OPERATIONS
ADMINISTRATION
FACILITY**

OPERATIONS LEVEL
& ADMINISTRATION BLDG.

Sheet Contents


**MAINTENANCE
BUILDING
NORTH WEST
EXTERIOR
ELEVATIONS**

TMA 578'
Project Number


3-22-83
Date 3-15-83

Sheet **A3.1** of 101


© COPYRIGHT RESERVED

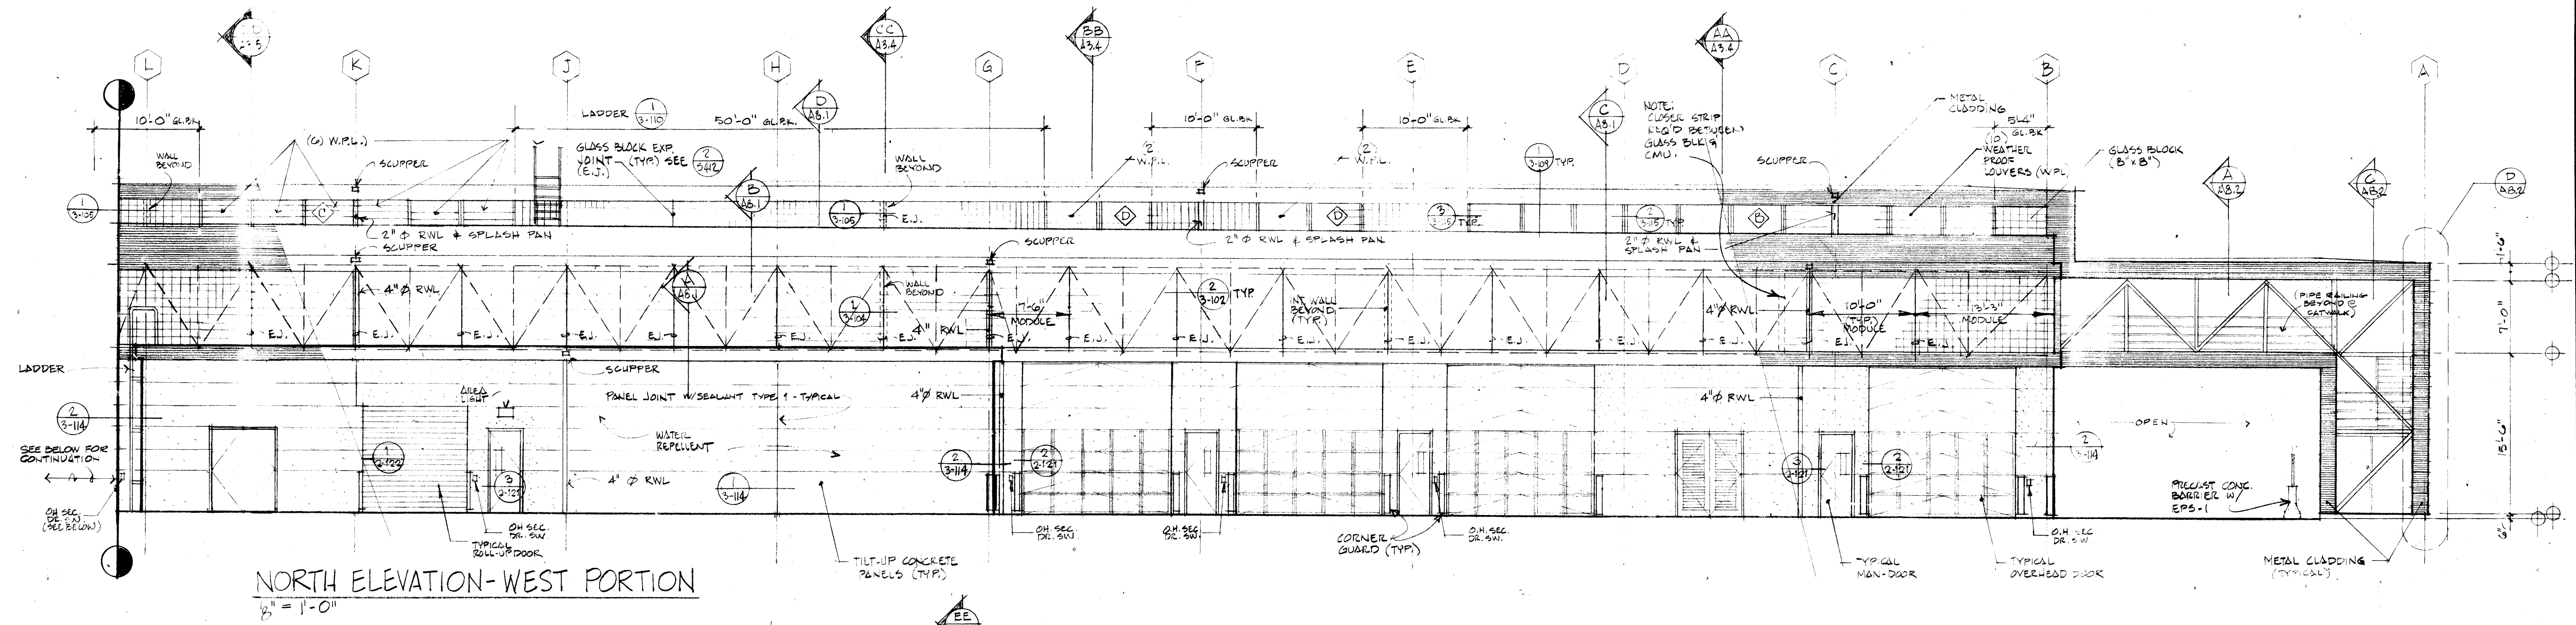


NORTH ELEVATION - WEST PORTION
3" = 1'-0"

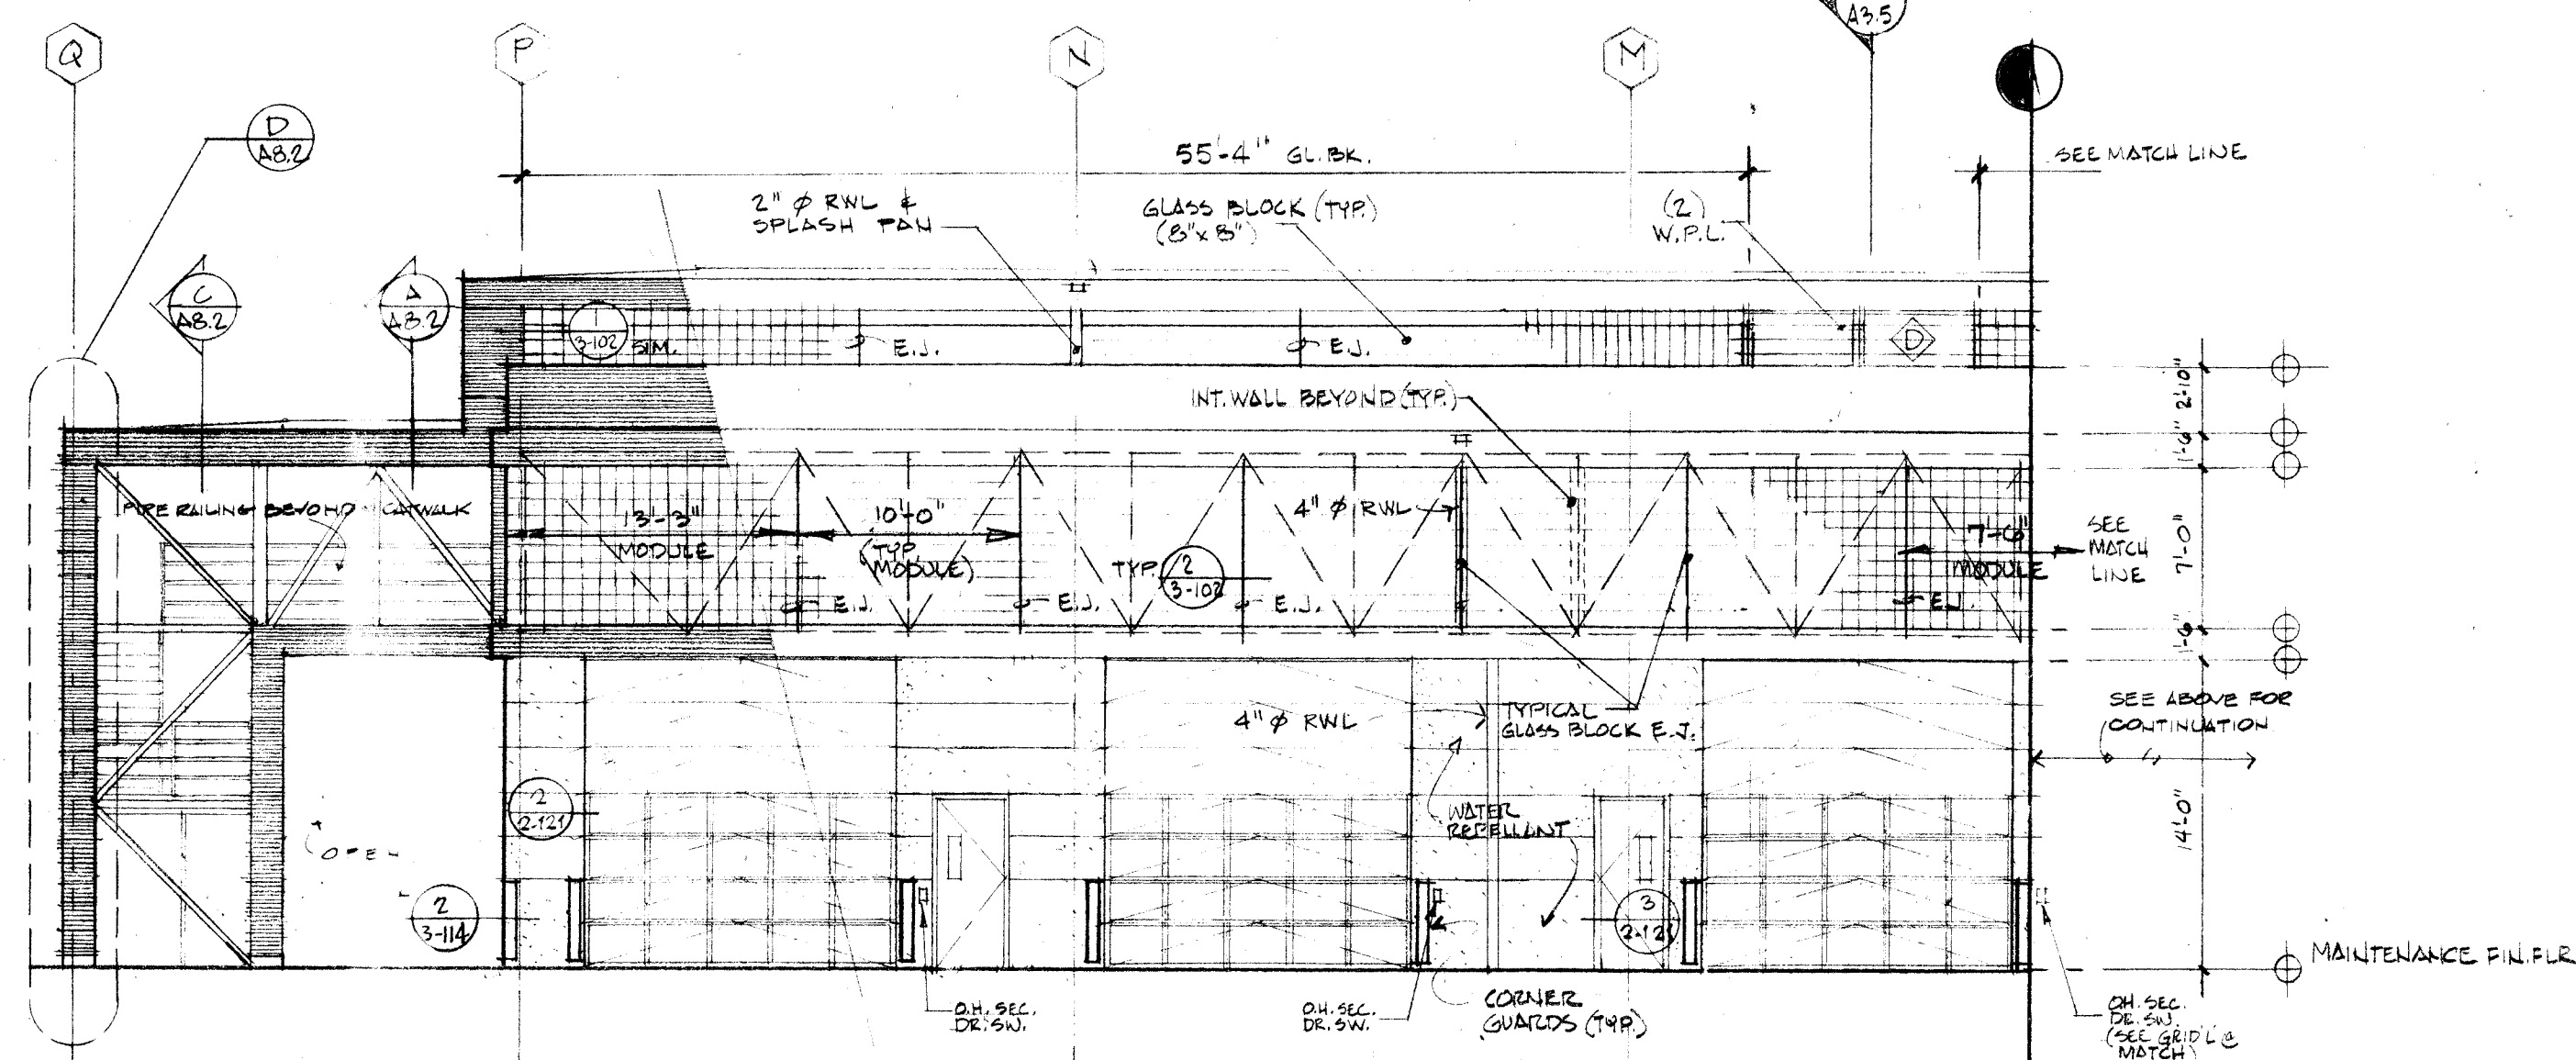

NORTH ELEVATION - EAST PORTION
3" = 1'-0"

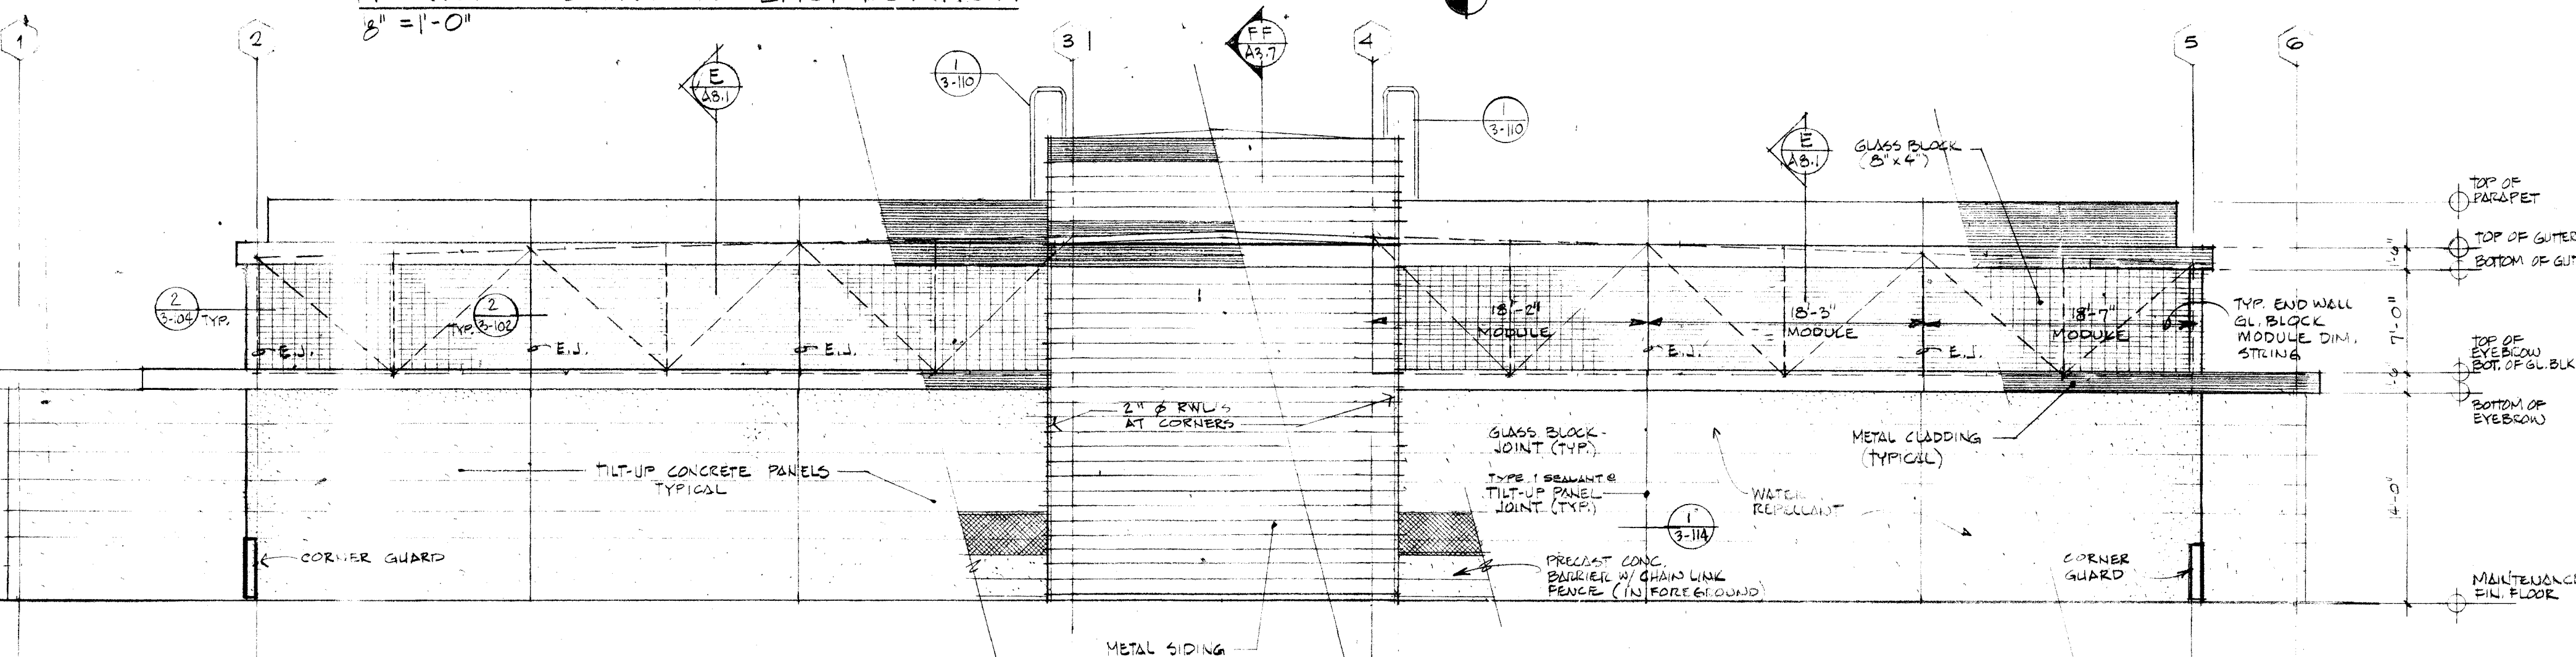


WEST ELEVATION
3" = 1'-0"

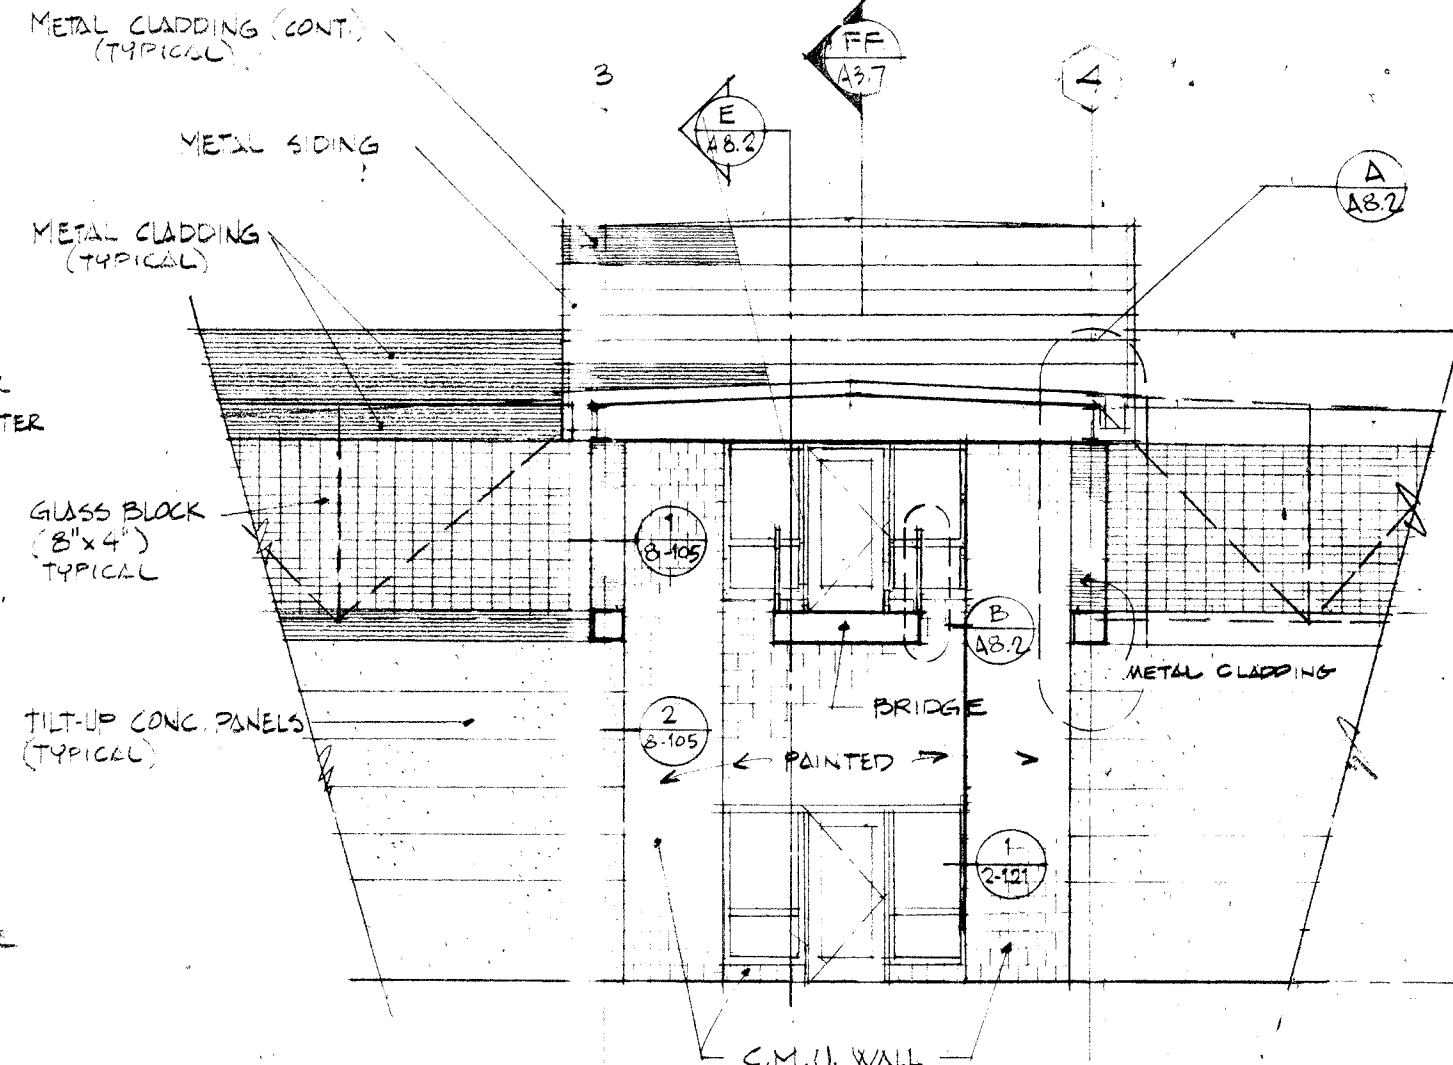

WEST ELEVATION @ ENTRANCE
3" = 1'-0"

- NOTE:**
1. SEE A3.1 FOR SWITCH ABBREVIATIONS
 2. REFER TO SHT. A3.1 FOR TYP. GLASS BLOCK MODULE DIMENSIONS ON EAST & WEST ELEVATIONS.
 3. REFER TO SHT. A3.1 FOR GLASS BLOCK MODULE DIMENSIONS OPPOSITE HAND FOR DIMENSIONS ON UPPER CLEARSTORY GLASS BLOCK.
 4. ALL MET. CLADDING RECEIVES EPS-20 OR EPS-21 AS SELECTED BY ARCHITECT

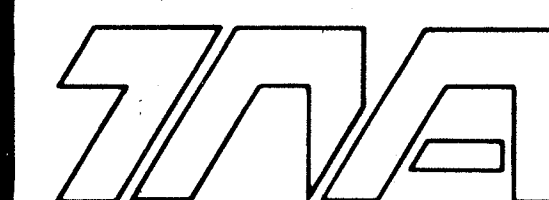

**Tsang
Merritt
Associates**

**Architecture
Engineering
Planning**

1701 Commerce
Tacoma
Washington
98402-3207

206
383-1987

Members of
the American
Institute of
Architects

3005 REGISTERED ARCHITECT
JAMES C. TSANG
STATE OF WASHINGTON

2440 REGISTERED ARCHITECT
JAMES R. MERRITT
STATE OF WASHINGTON



INTERCITY TRANSIT

526 South Pattison Street
Olympia, Washington

**TRANSIT
MAINTENANCE
OPERATIONS
ADMINISTRATION
FACILITY**


Sheet Contents

MAINTENANCE
BUILDING
FLOOR PLAN
LOWER LEVEL
WEST PORTION

TMA 5781
Project Number

3-22-83
Date 3-15-83

Sheet A2.1 of 101
© COPYRIGHT RESERVED

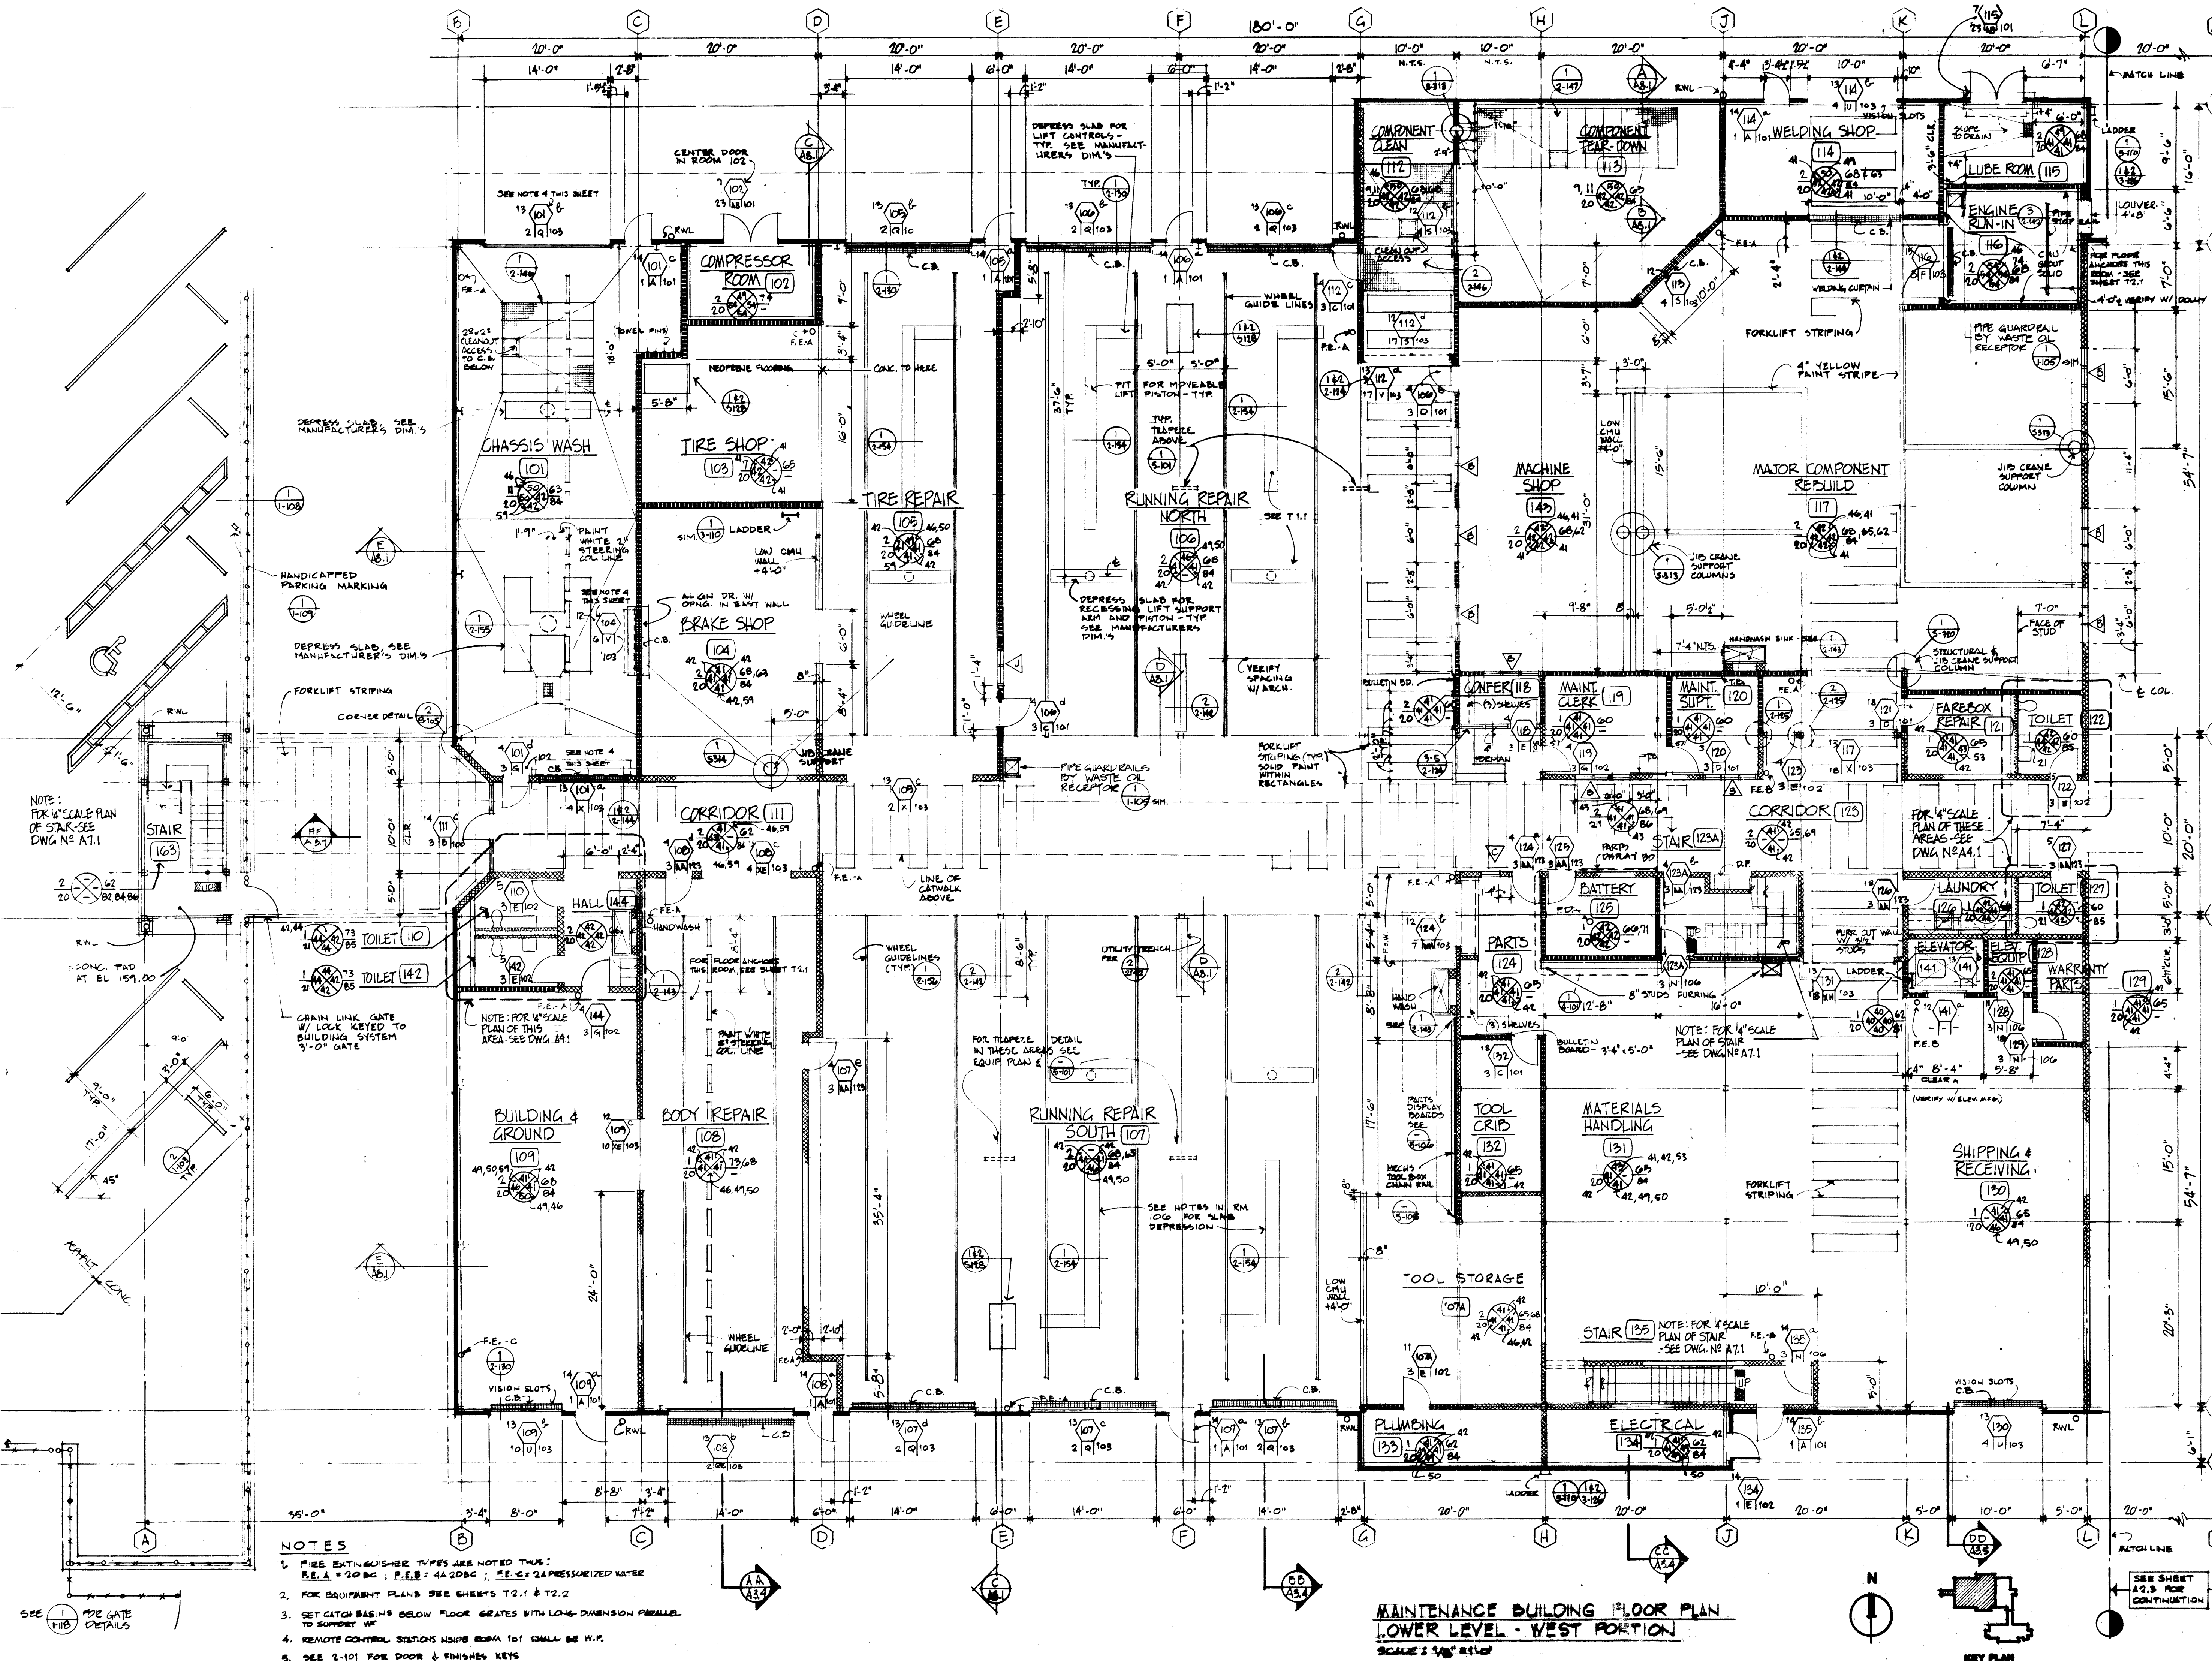

NOTES

1. FIRE EXTINGUISHER TYPES ARE NOTED THIS:
F.E.A = 20 BC ; F.E.B = 4A 20 BC ; F.E.C = 2A PRESSURIZED WATER
2. FOR EQUIPMENT PLANS SEE SHEETS T2.1 & T2.2
3. SET CATCH BASINS BELOW FLOOR GRATES WITH LONG-DIMENSION PARALLEL TO SUPPORT W/F
4. REMOTE CONTROL STATIONS INSIDE ROOM 101 SHALL BE W.P.
5. SEE 2-101 FOR DOOR & FINISHES KEYS

**MAINTENANCE BUILDING FLOOR PLAN
LOWER LEVEL - WEST PORTION**
SCALE: 1/8" = 1'-0"



KEY PLAN