



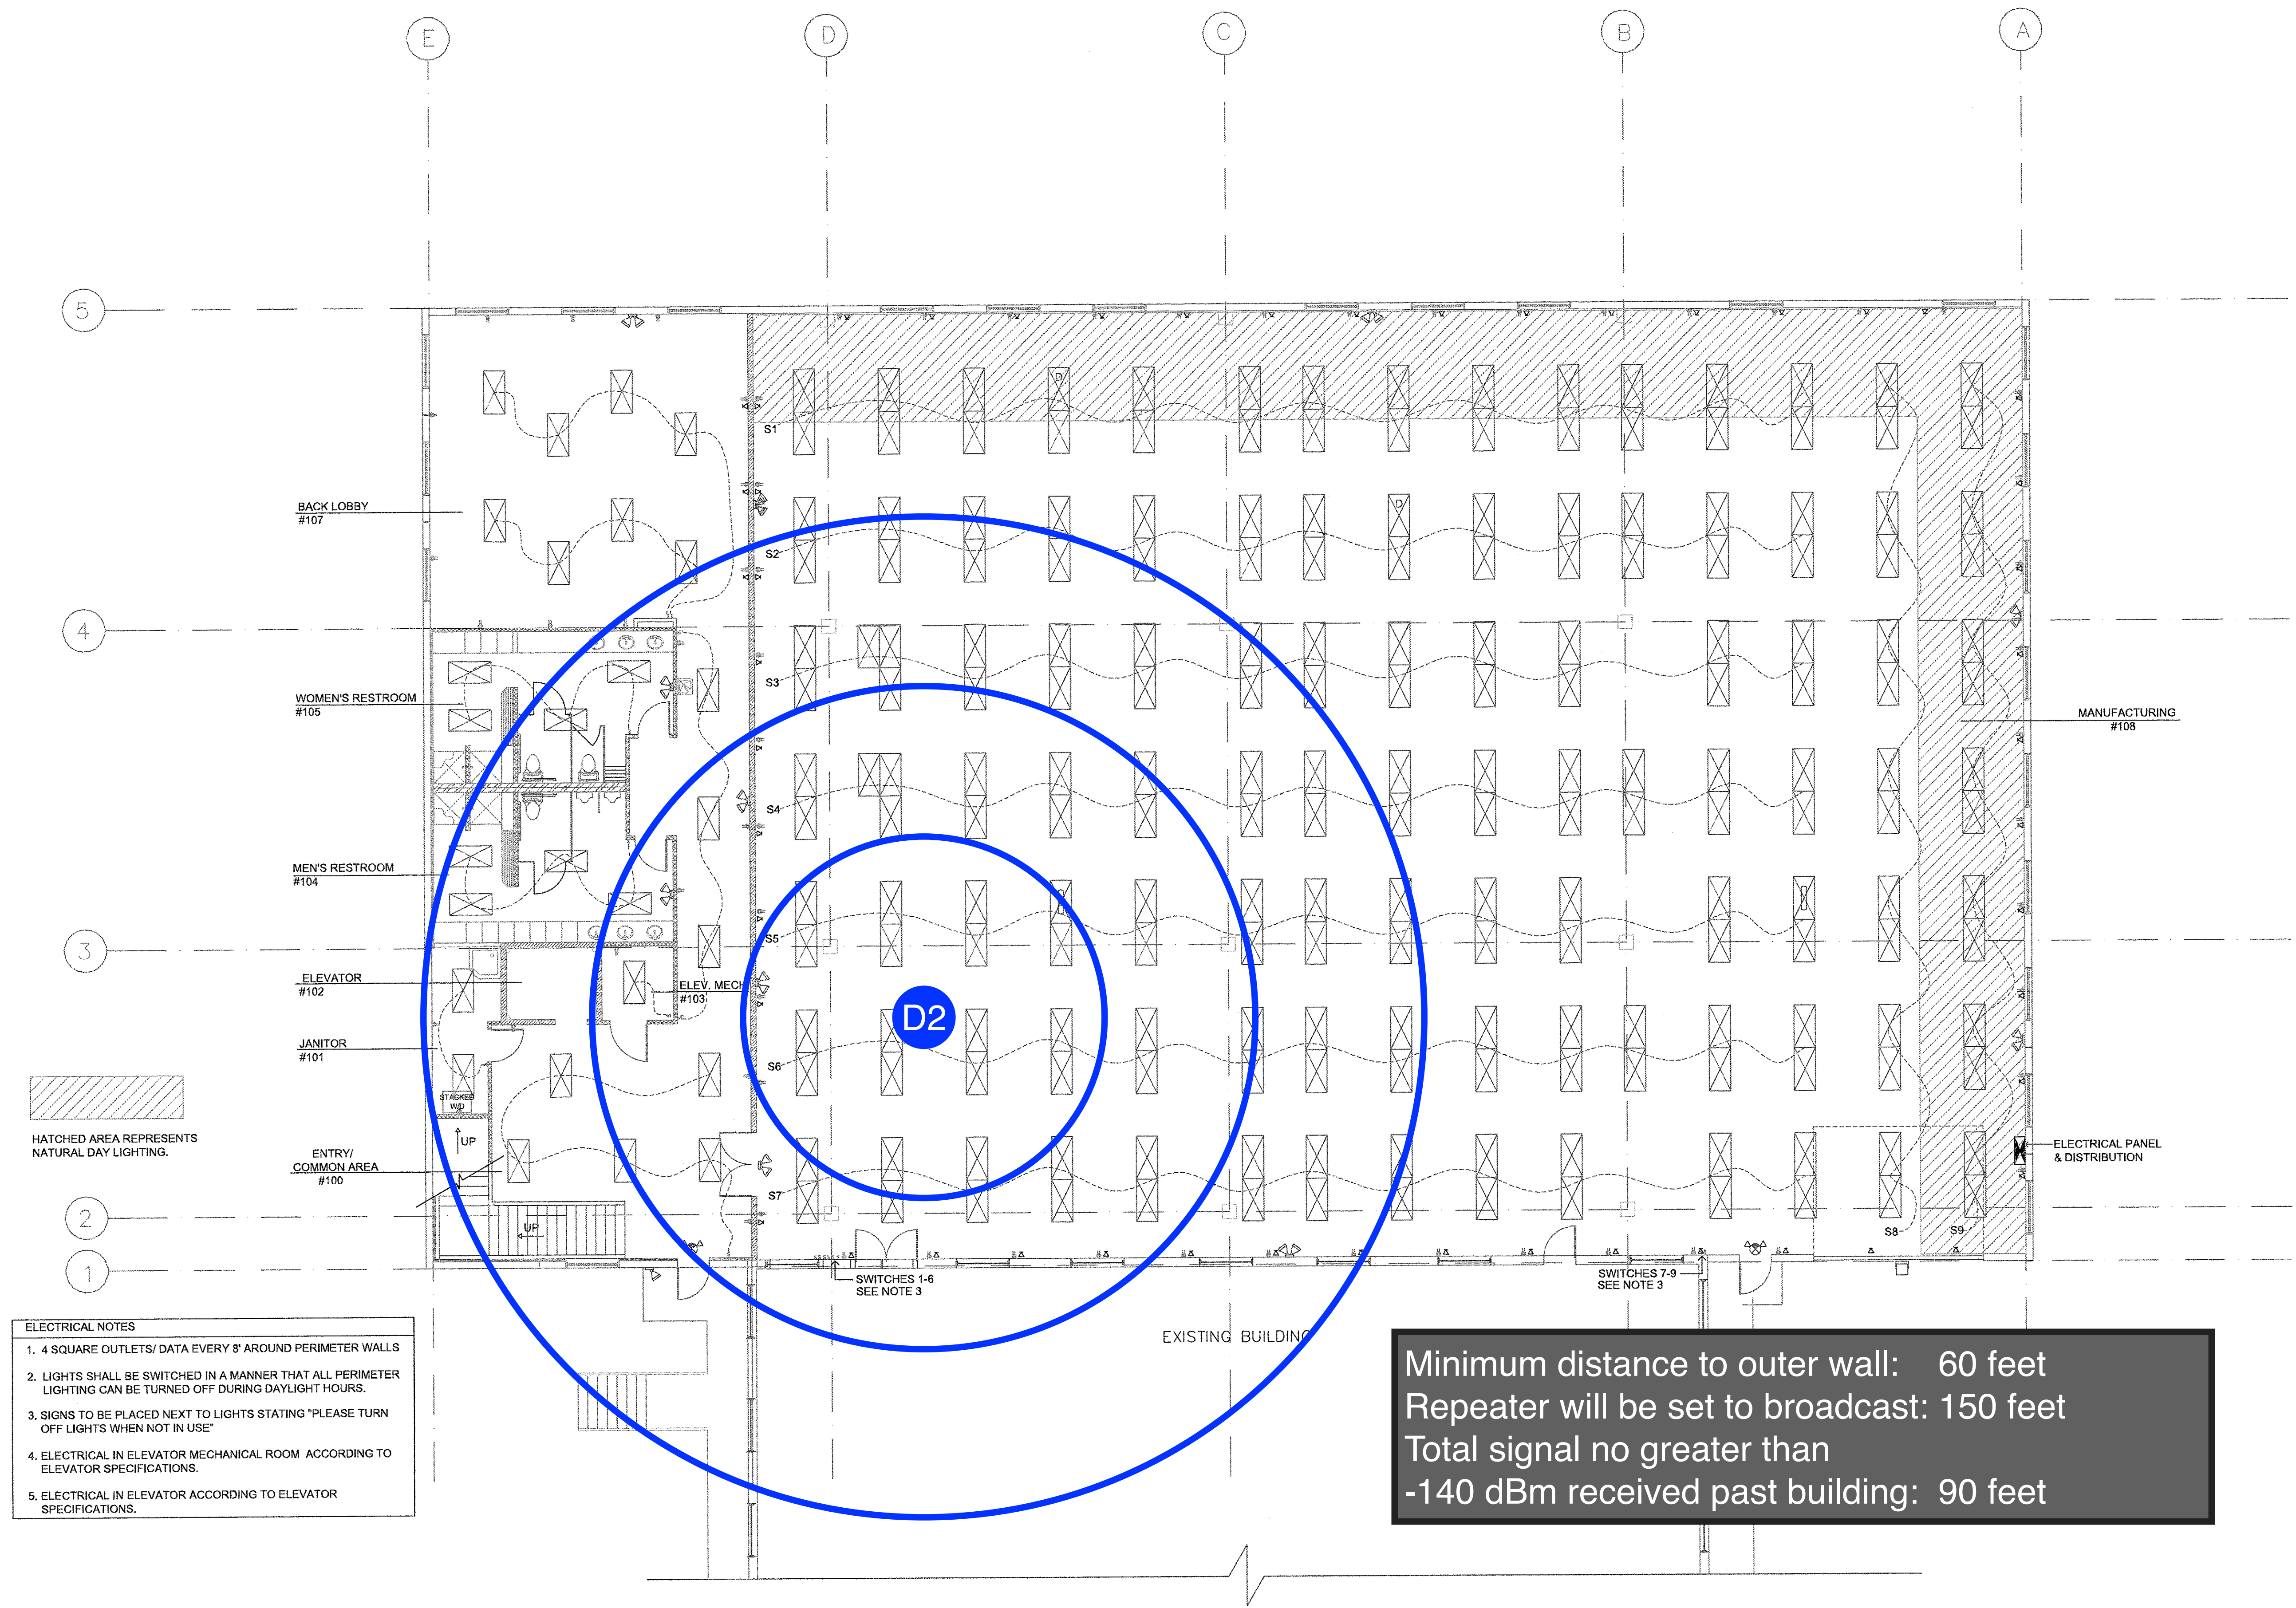

Minimum distance to outer wall: 60 feet
Repeater will be set to broadcast: 150 feet
Total signal no greater than
-140 dBm received past building: 90 feet

1 FIRST FLOOR ELECTRICAL PLAN
SCALE 1/8" = 1'-0"

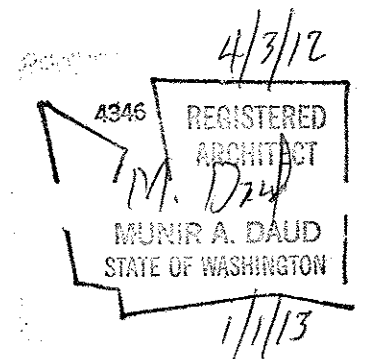

KBS DRAFTING & DESIGN: KARIN SETTLES PHONE: 509-592-2013 E-MAIL: ksettles@kbsdrafting.com www.kbsdrafting.com		PROJECT NAME: DECAGON ADDITION	DATE: 03-25-12	SIZE: D
		FIRST FLOOR SCHEMATIC ELECTRICAL PLAN	SCALE: 1/8" = 1'	SECTION: E1.0
		PROJECT ADDRESS: 2365 N.E. HOPKINS CT. PULLMAN, WA 99163		SHEET: