

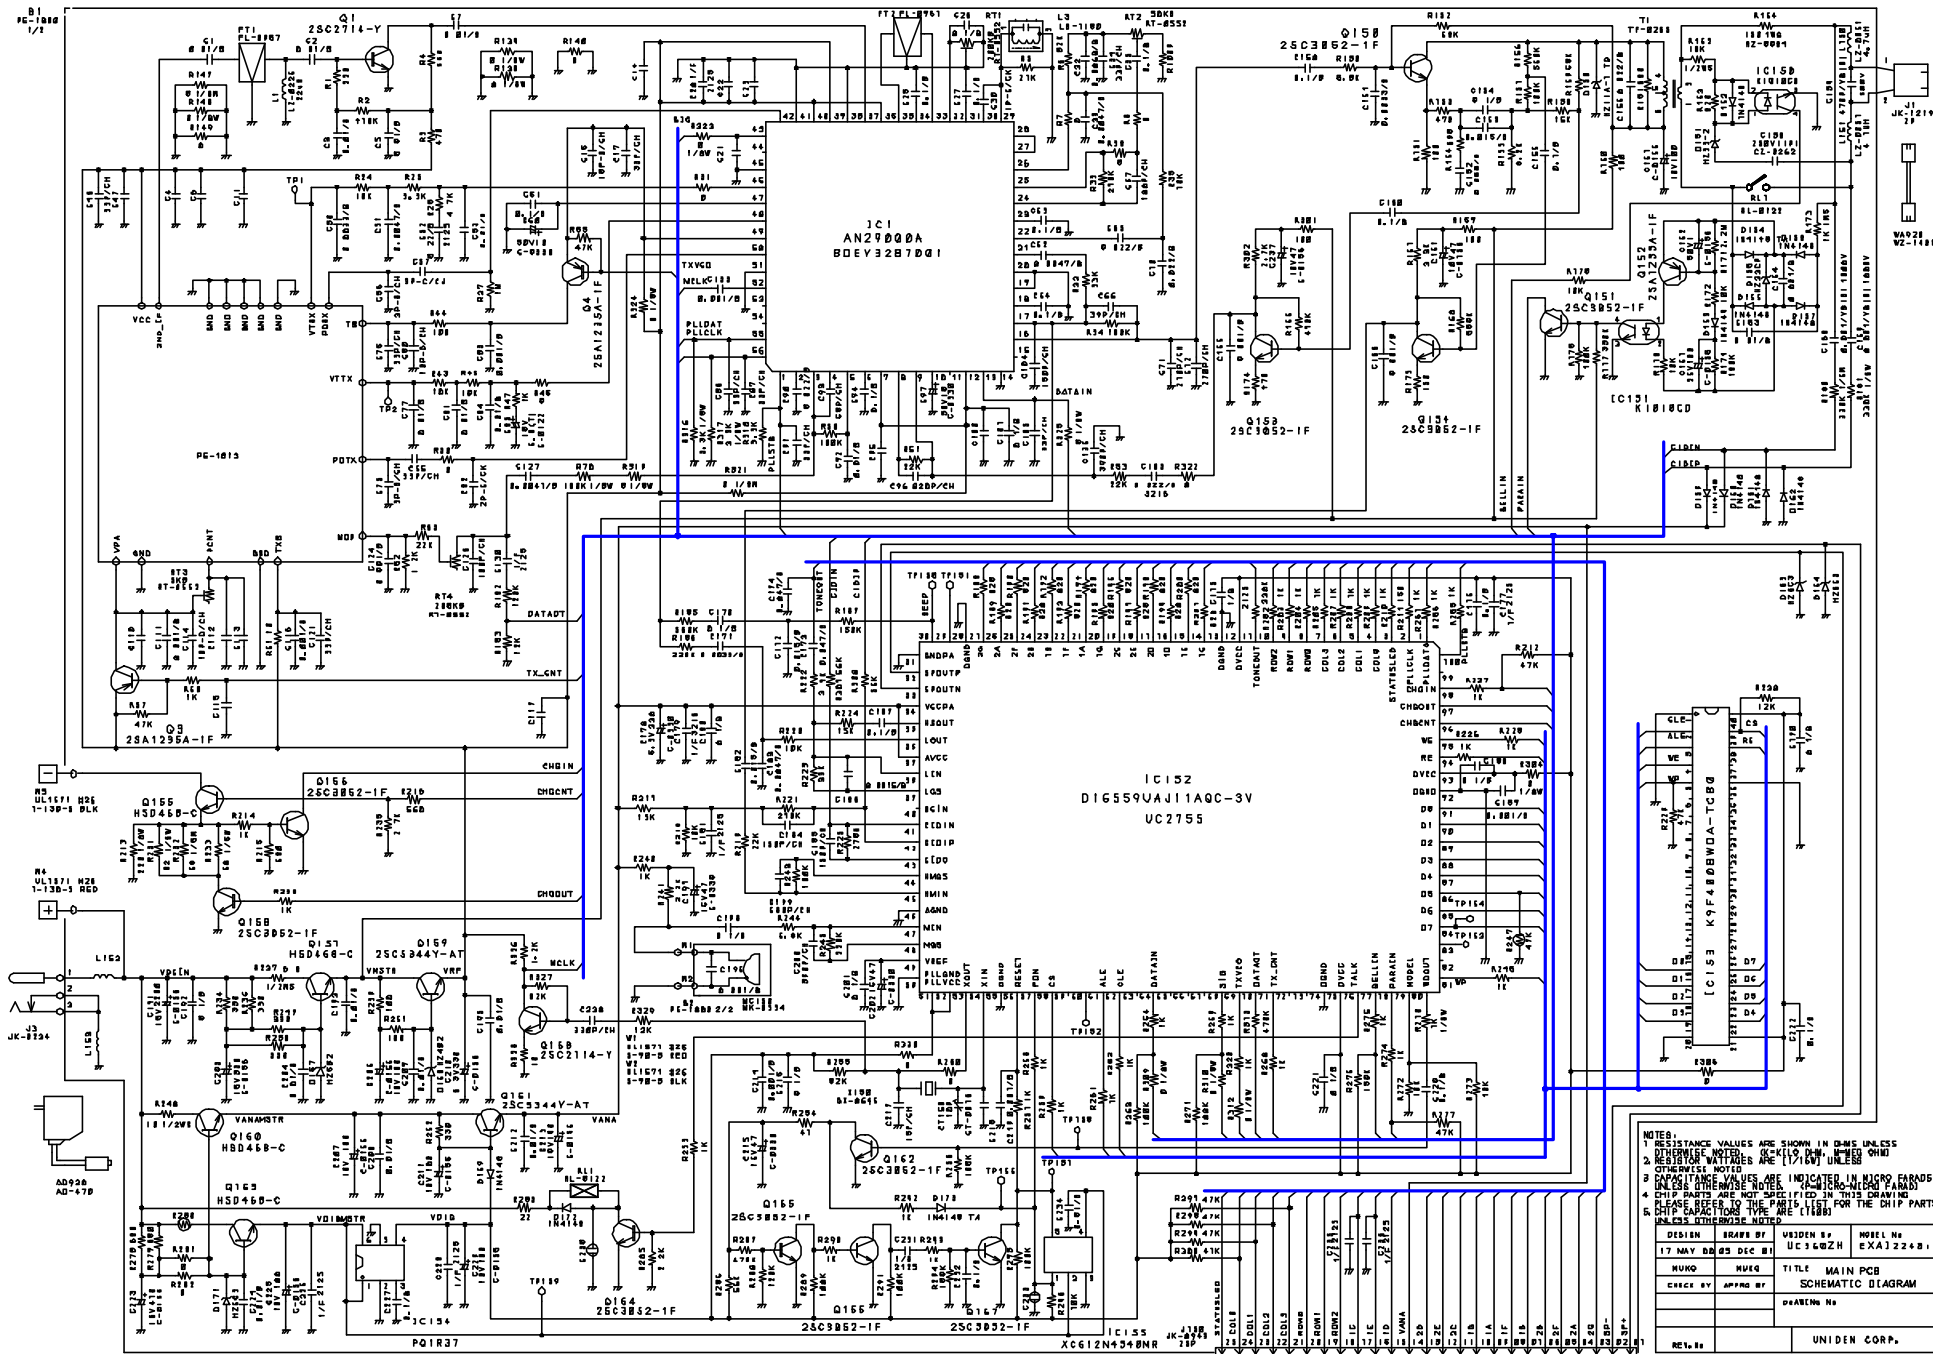


[illegible]

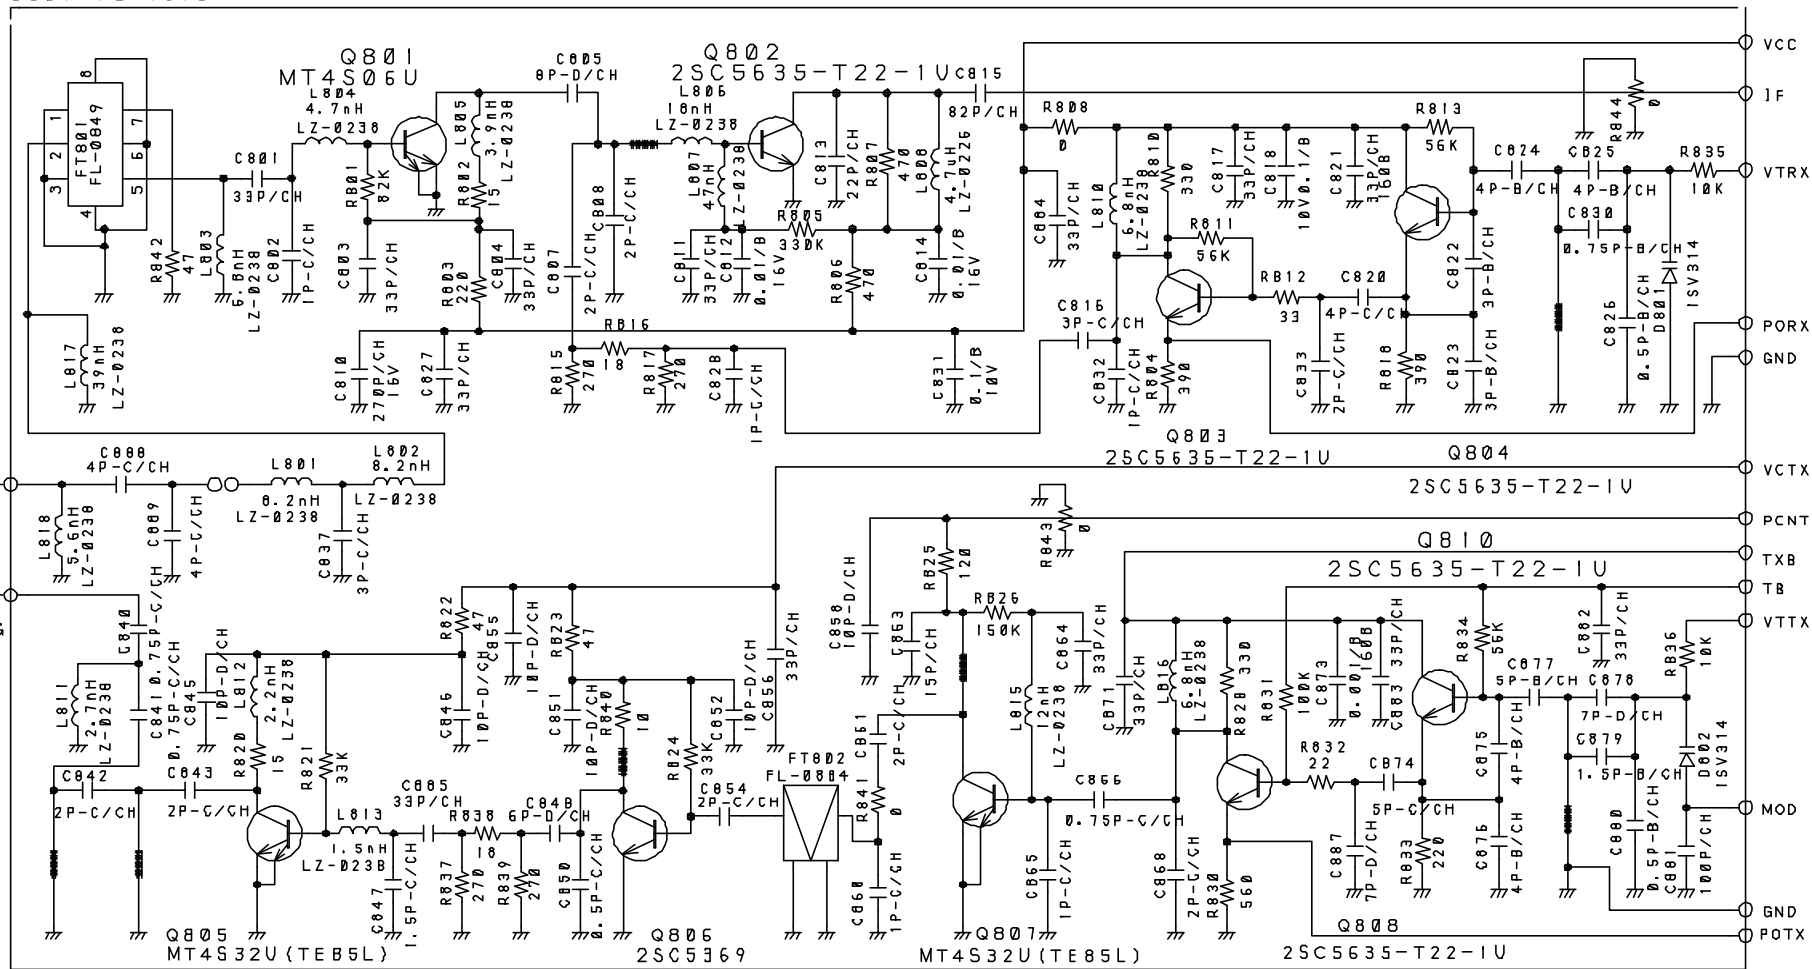


1. RESISTANCE VALUES ARE SHOWN IN OHMS UNLESS OTHERWISE NOTED. (K=KILLO OHM, M=MEG OHM)
2. RESISTOR WATTAGES ARE [1/16W (1005)] UNLESS OTHERWISE NOTED.
3. CAPACITANCE VALUES ARE INDICATED IN MICRO FARADS UNLESS OTHERWISE NOTED. (P=MICRO-MICRO FARAD)
4. CHIP PARTS ARE NOT SPECIFIED IN THIS DRAWING PLEASE REFER TO THE PARTS LIST FOR THE CHIP PARTS.
5. CHIP CAPACITORS TYPE ARE [1005] UNLESS OTHERWISE NOTED.

DESIGN	DRAWN BY	UNIDEN No.	MODEL No.
May/14/01	01/12/05	UC360ZH	EXA12248i
YU1	SUWA	TITLE BASE RF	
CHECK BY	APPRO. BY	SCHEMATIC DIAGRAM	
		DRAWING No	
REV No		UNIDEN CORP.	

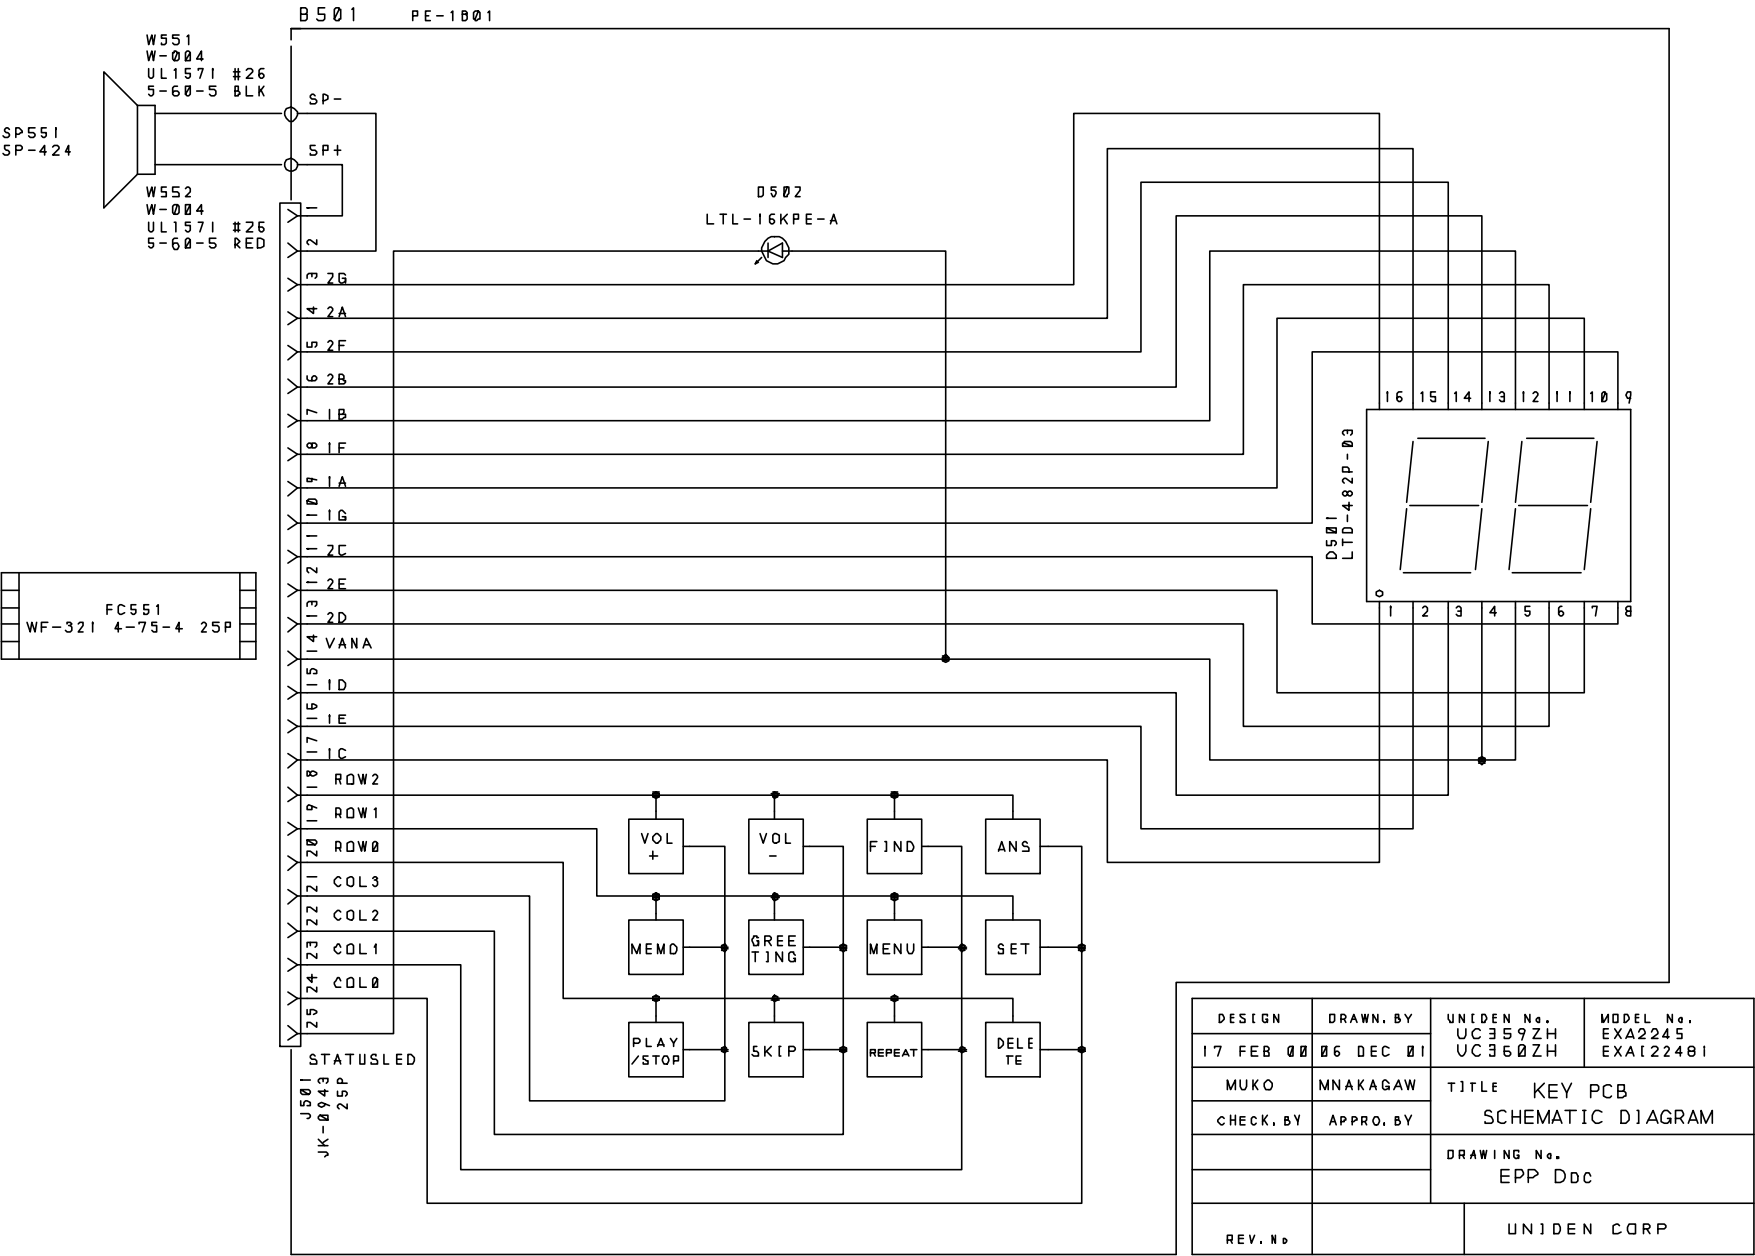

DESIGN	DRAWN BY	UNIDEN No. UC359ZH	MODEL No. EXA2245
17 FEB 00	06 DEC 01	UC360ZH	EXA122401
MUKO	MNAKAGAW	TITLE KEY PCB	
CHECK BY	APPRO BY	SCHEMATIC DIAGRAM	
		DRAWING No.	
		EPP Ddc	
REV. No.		UNIDEN CORP	

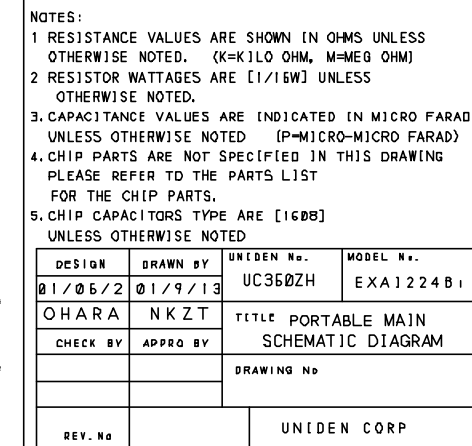

NOTES:

- 1 RESISTANCE VALUES ARE SHOWN IN OHMS UNLESS OTHERWISE NOTED. (K=KILO OHM, M=MEG OHM)
- 2 RESISTOR WATTAGES ARE [1/15W] UNLESS OTHERWISE NOTED.
3. CAPACITANCE VALUES ARE INDICATED IN MICRO FARAD UNLESS OTHERWISE NOTED [P=MICRO-MICRO FARAD]
4. CHIP PARTS ARE NOT SPECIFIED IN THIS DRAWING PLEASE REFER TO THE PARTS LIST FOR THE CHIP PARTS.
5. CHIP CAPACITORS TYPE ARE [160B] UNLESS OTHERWISE NOTED

DESIGN	DRAWN BY	UNIDEN No.	MODEL No.
01/05/2	01/9/13	UC350ZH	EXA1224B1
OHARA		TITLE PORTABLE MAIN SCHEMATIC DIAGRAM	
CHECK BY	APPRO BY	DRAWING No	
REV. No		UNIDEN CORP	

