



DASH NO.	ECN	REV	DESCRIPTION	DATE	APPROVED
C266	B1		RELEASE PER ECN C266	3/6/98	BH
B983	B2		RELEASE PER ECN B983	3/16/98	
B902	B3		RELEASE PER ECN C302	3/16/98	<i>Pgm</i>

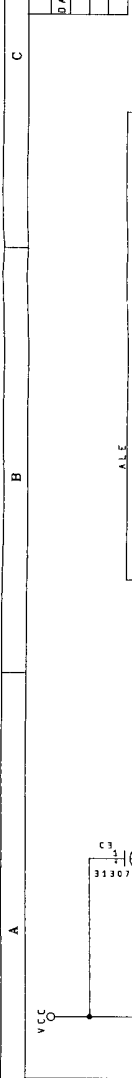


LAST USED REFDES #	REFDES RANGE	REFDES DESCRIPTION
U1 R7 C9 L9 K9	0 - 24	MICROCONTROLLER
U2 R4 C5	25 - 49	OSC
U25 R26 C34 L25	50 - 74	DDC
U50 R32 C23 K25	75 - 99	CLOCK CIRCUITS
U75 R78 C80 L75	100-149	CCFL INVERTER
U150 R137 C164 L53	150-174	MISC LOGIC
U226 R206 C205 L206	200-249	POWER/BYPASS CAPS
U255 R281	250-299	MISC LOGIC
U300 R305 C303	300-324	MRI/VERTICAL
	400-449	RS232
U450 R457 C473	450-499	CPLD
U502 R554 C518	500-599	RED VIDEO
U602 R654 C618	600-699	GREEN VIDEO
U702 R754 C718	700-799	BLUE VIDEO
U802 R854 C818	800-829	OTHER VIDEO
U835 R865 C835 L835	830-874	VIDEO OUTPUT SECTION
U876 R886 C886 L886	875-899	ANALOG POWER
	900-950	MISC INTERFACE BOARD

LAST CONNECTOR - J14

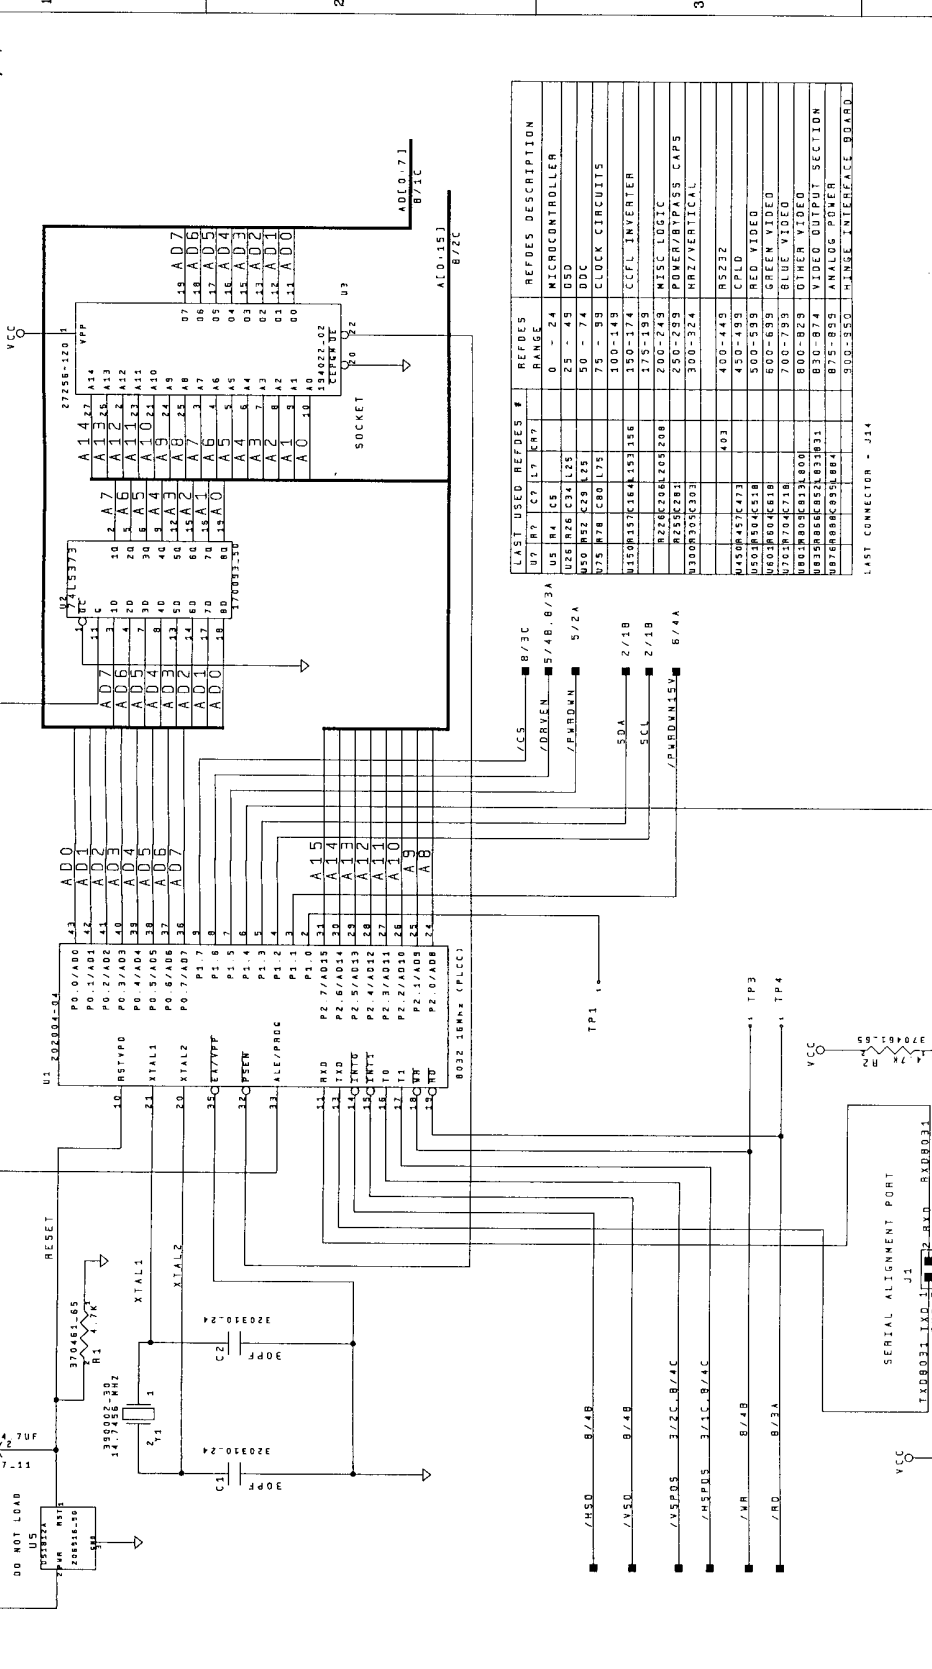


CONTRACT NO	APPROVAL	DATE
	DWN 808 HYMES	
	CHK	
	ENG 808 HYMES	
	ISSUED	

WYSE TECHNOLOGY
INCORPORATED

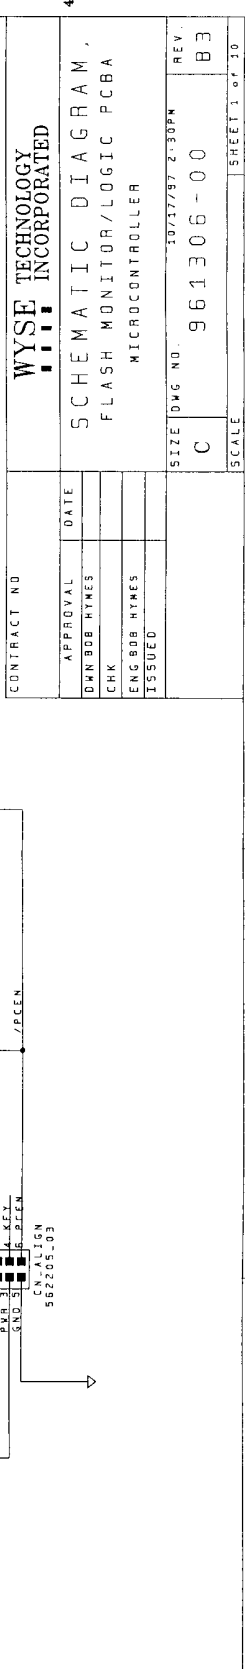

SIZE	DWG NO.	REV.
C	961306-00	B3

10/17/97 2:30PM
SHEET 1 of 10

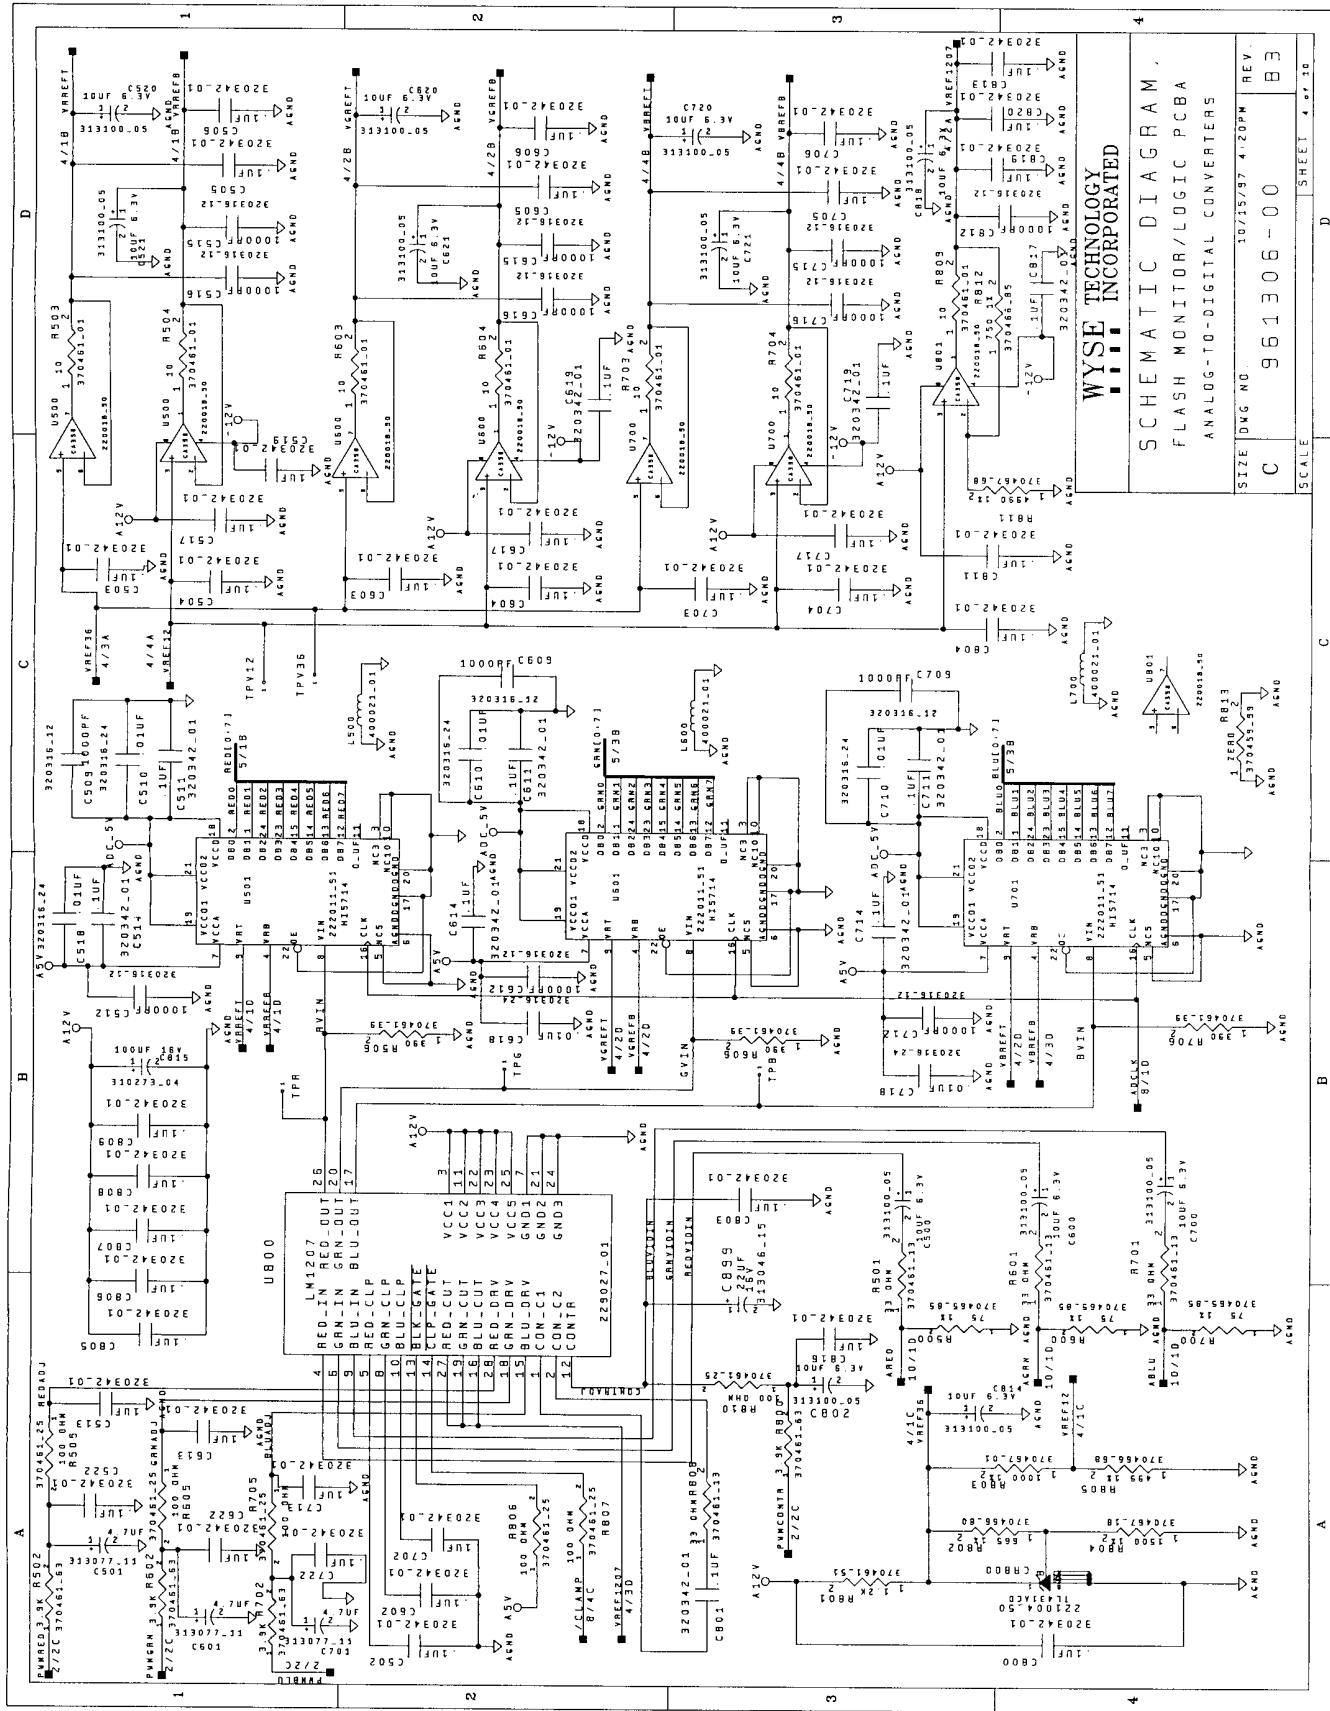



WYSE TECHNOLOGY
INCORPORATED


SCHEMATIC DIAGRAM
FLASH MONITOR/LOGIC PCBA
ANALOG-TO-DIGITAL CONVERTERS

SIZE DWG NO. 10/15/97 4:20PM REV. B3
C 961306-00

SCALE SHEET 4 OF 10

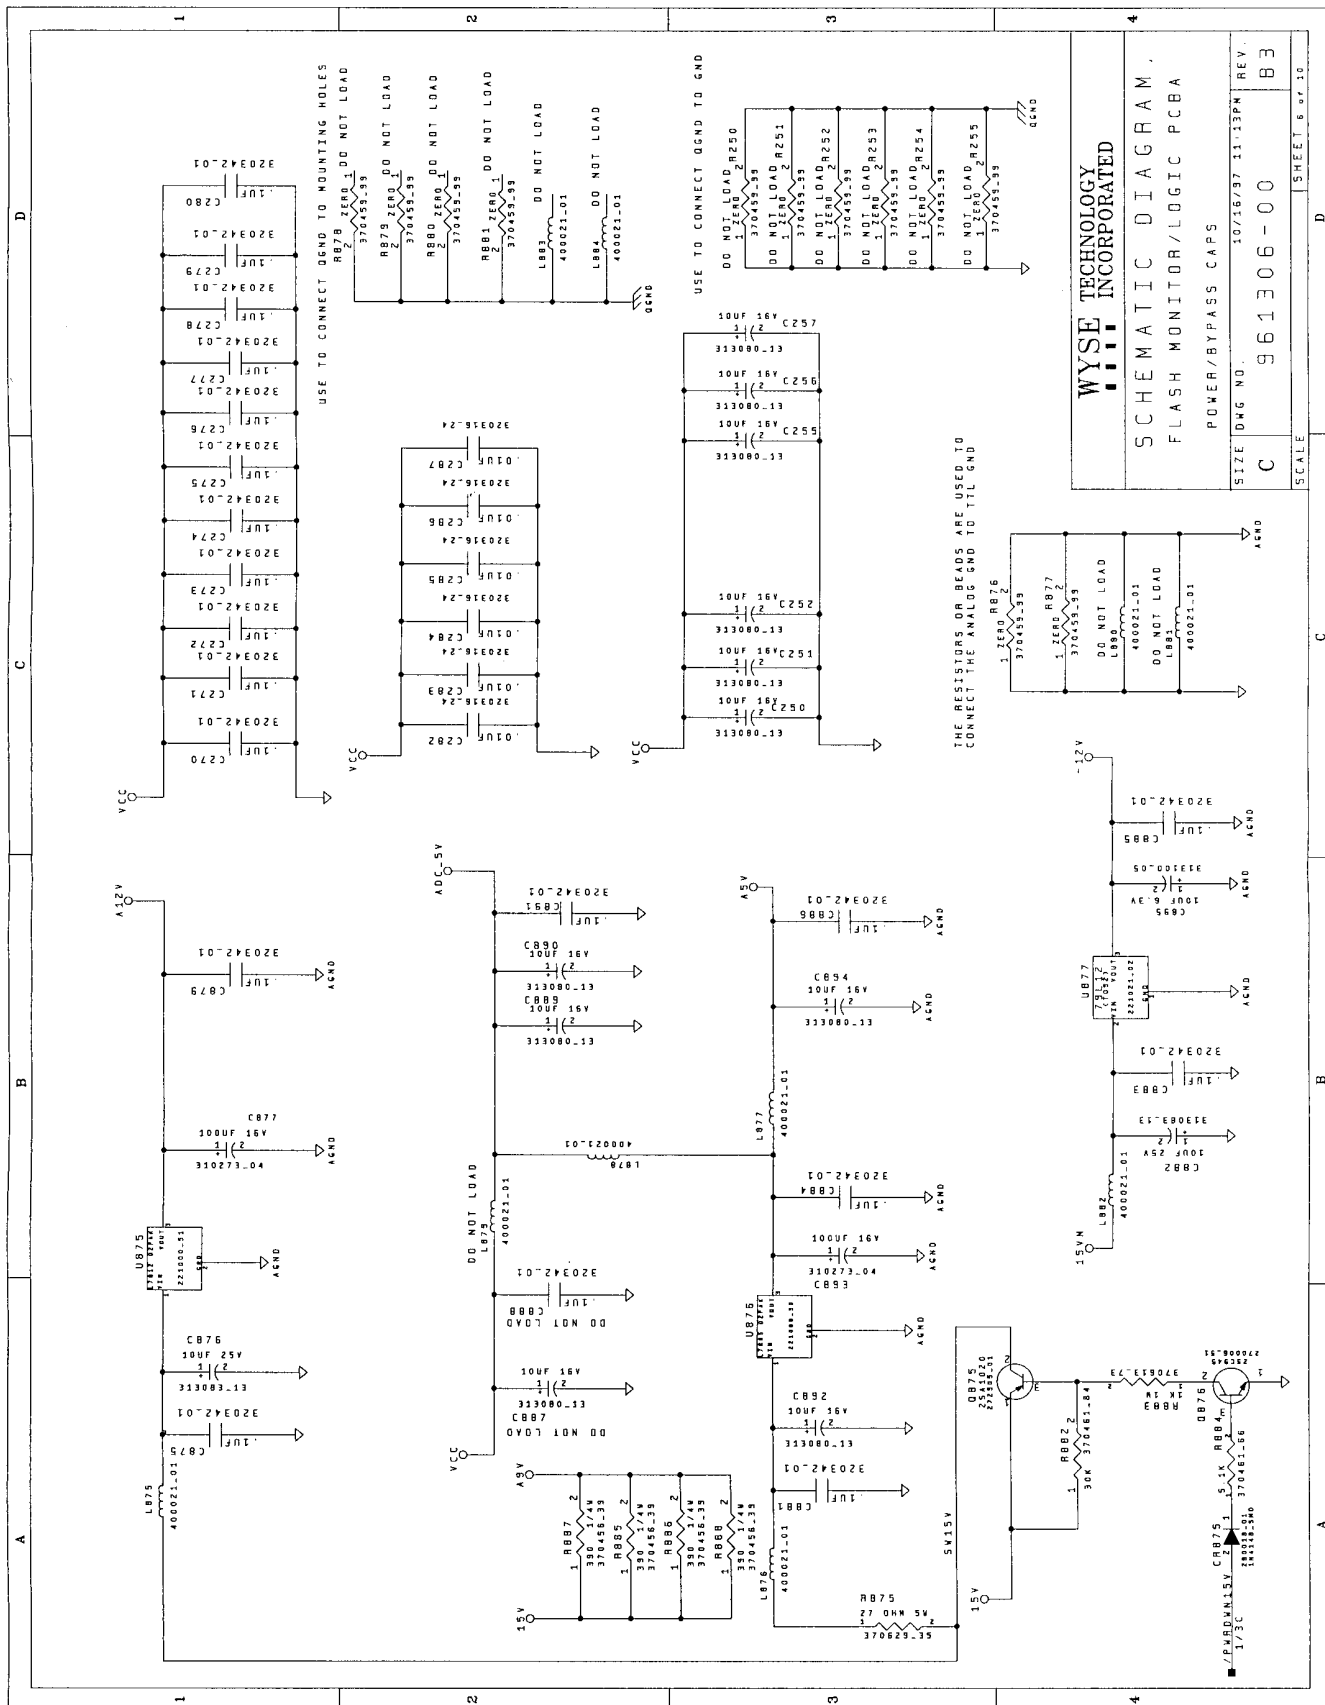

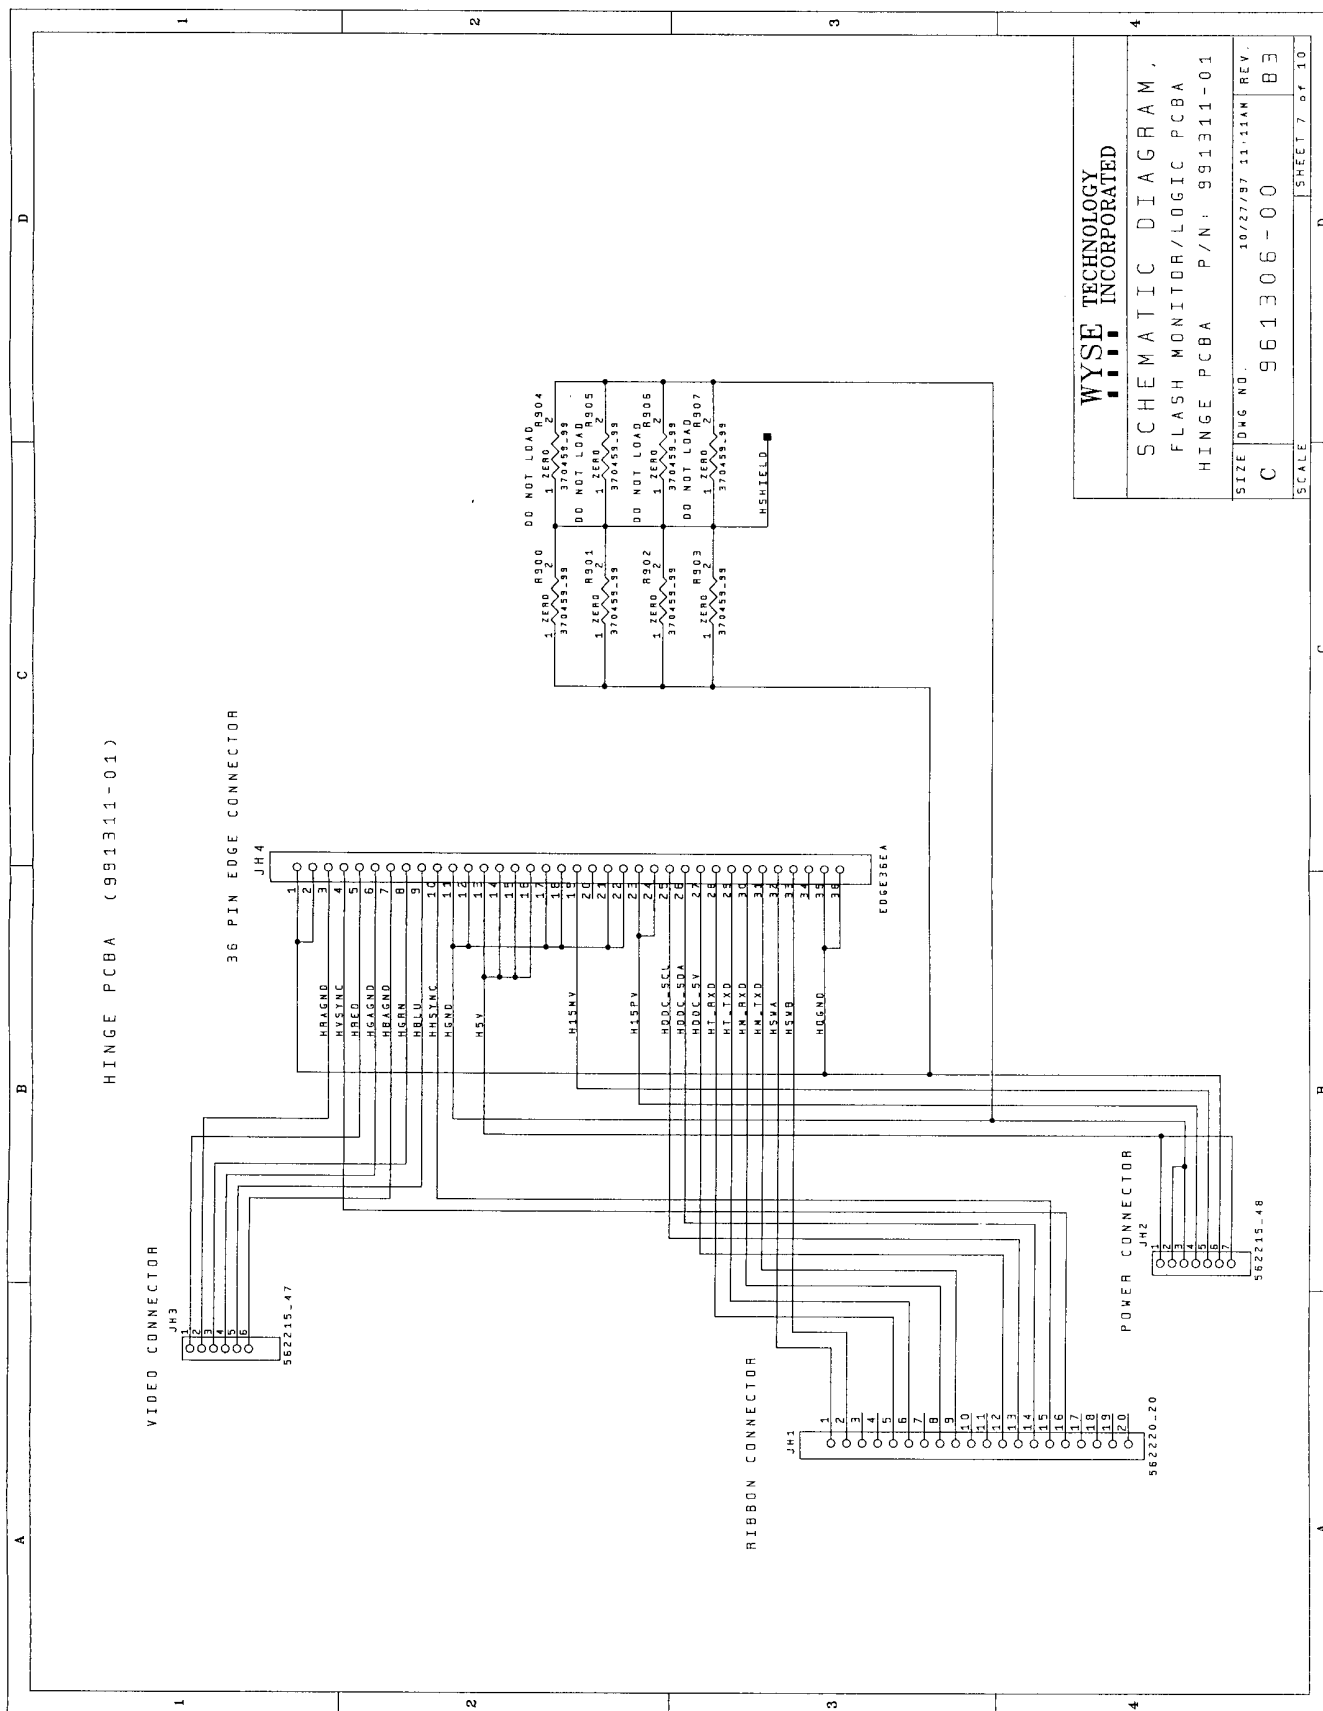

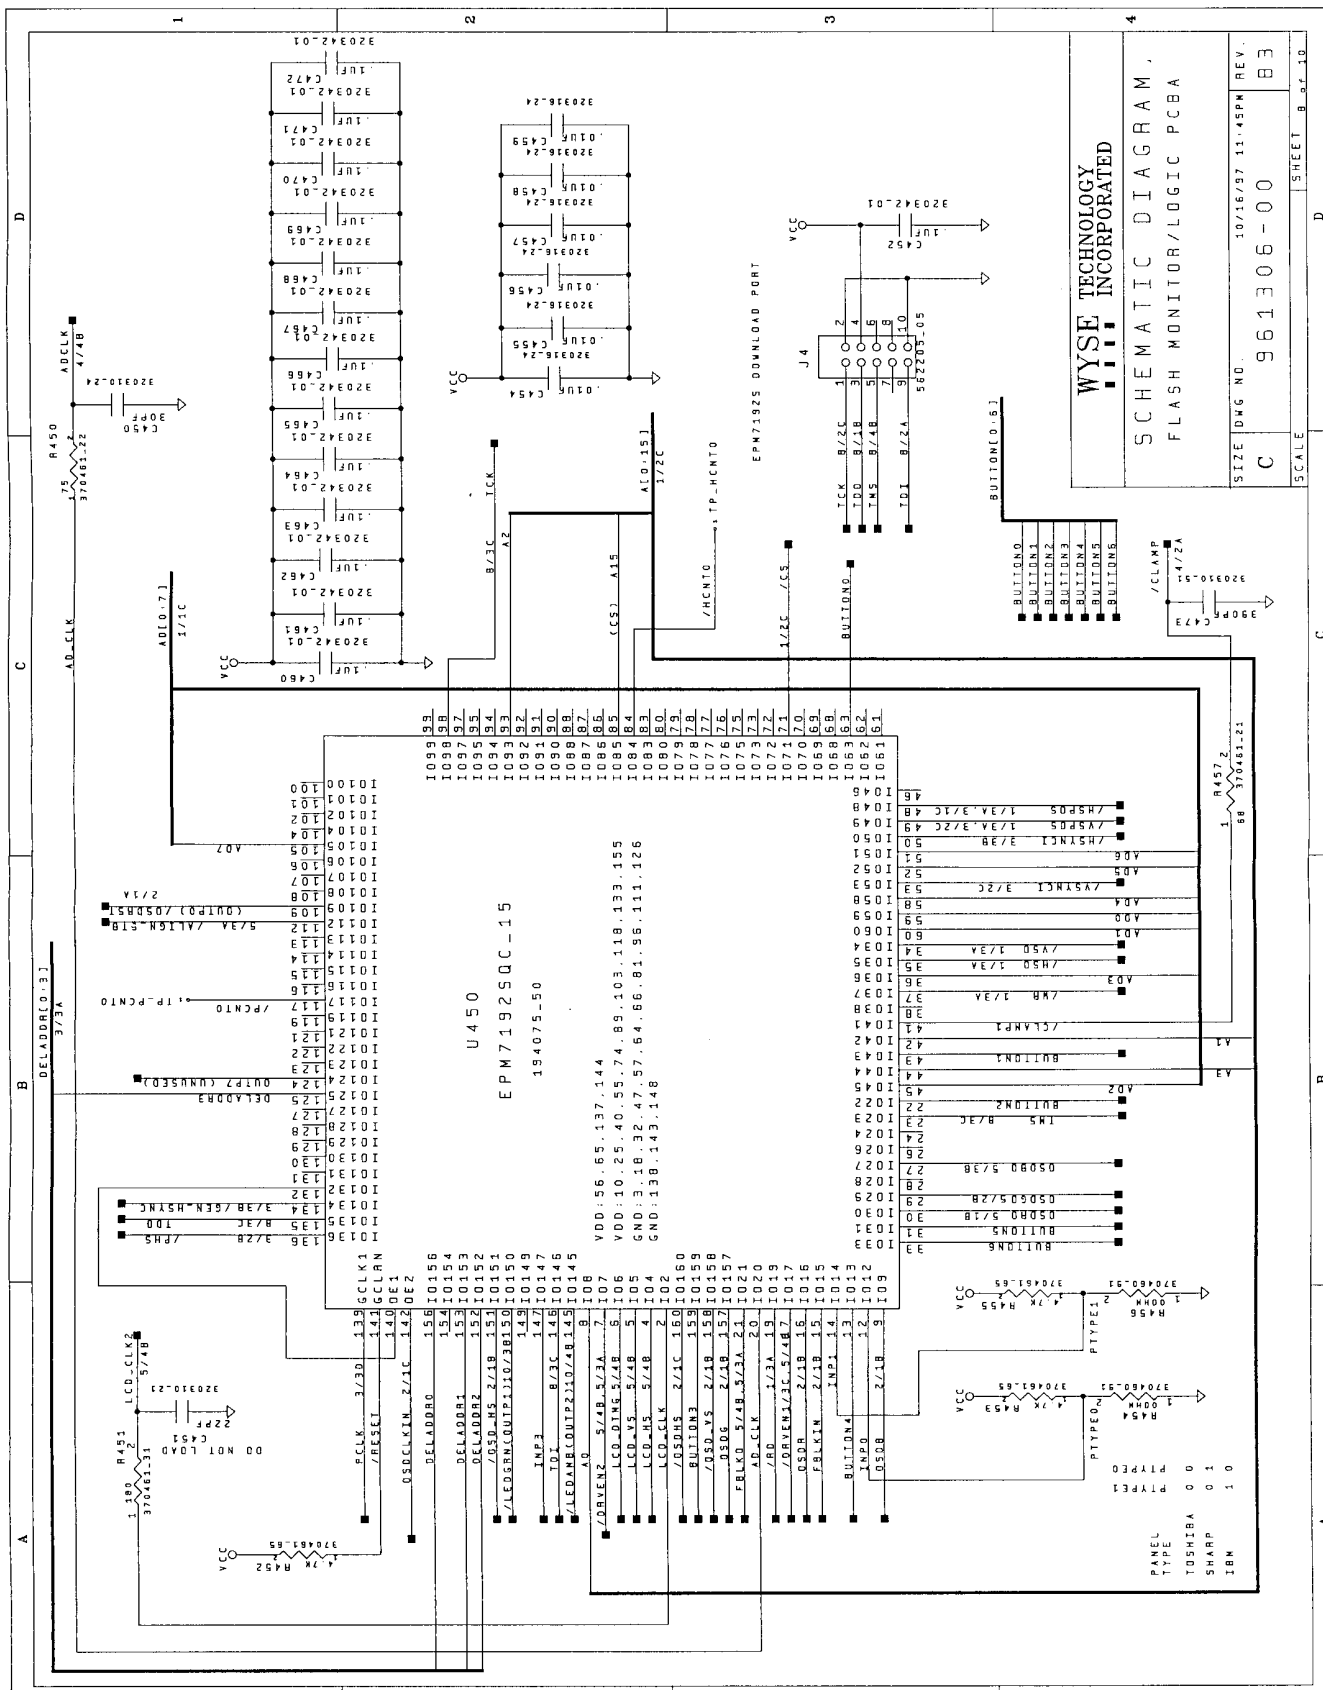

WYSE TECHNOLOGY
INCORPORATED

SCHEMATIC DIAGRAM,
FLASH MONITOR/LOGIC PCBA

SIZE DWG NO. 10/16/97 11:45PM REV. B3
C 961306-00

SCALE SHEET B of 10

