


EXHIBIT F

Block Diagram

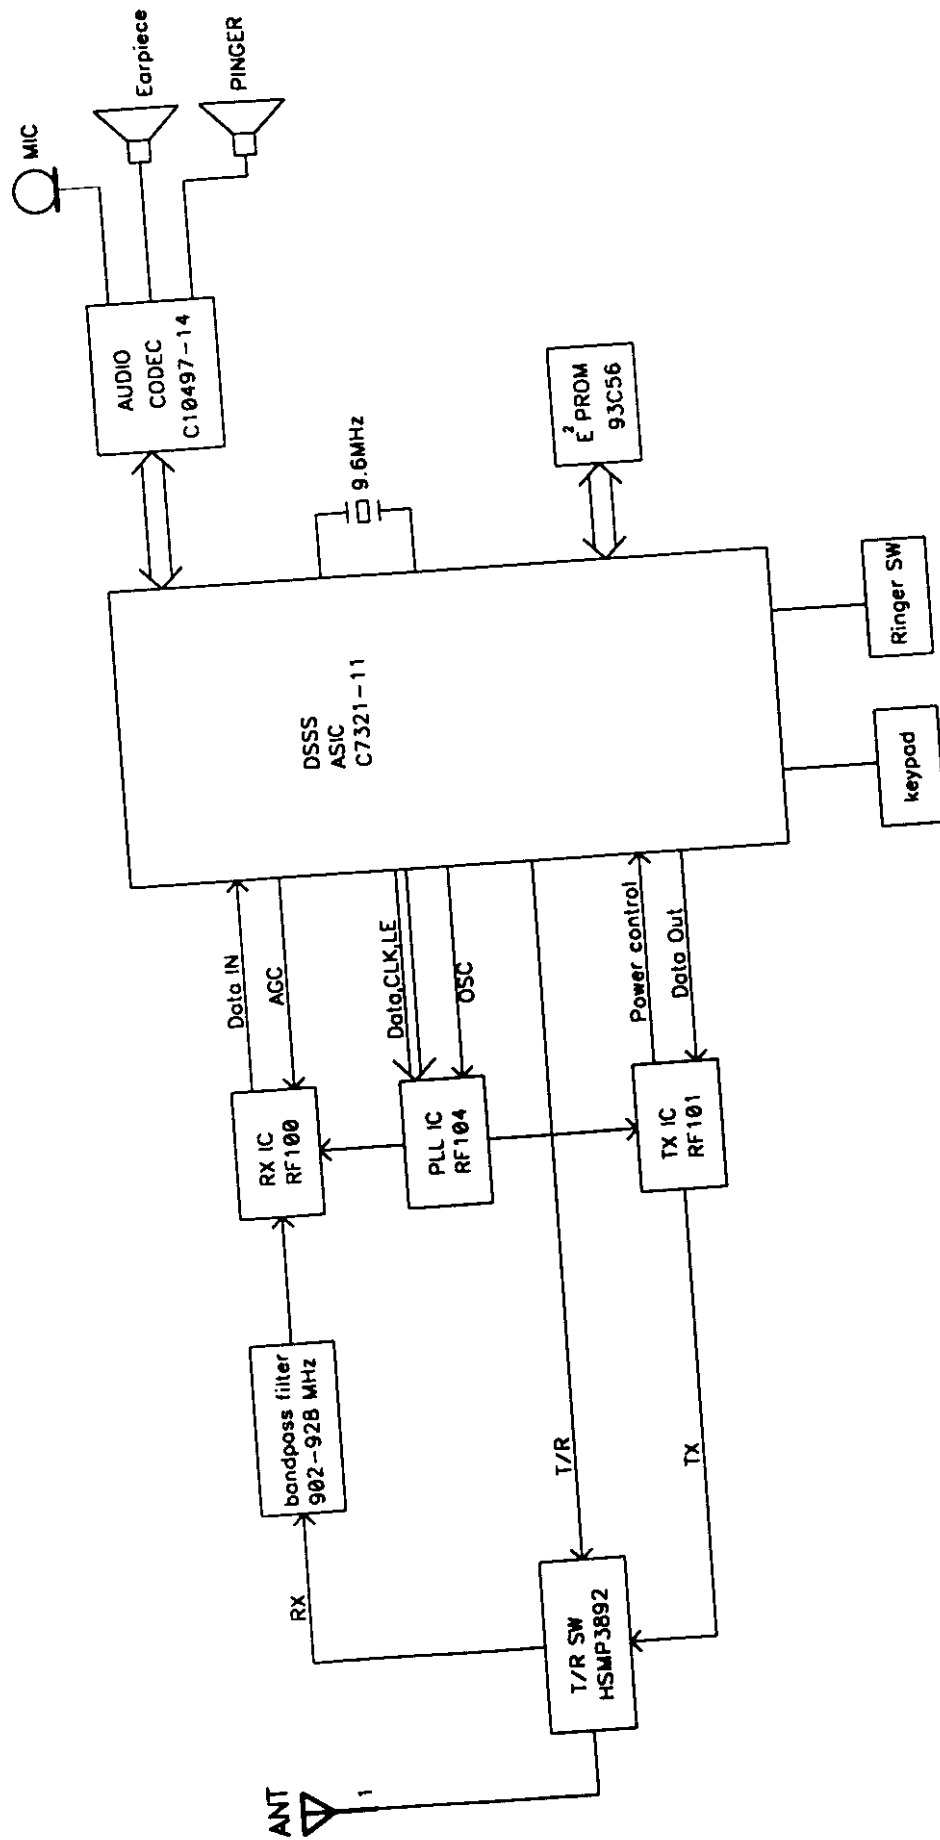

Title KINPO ELECTRONICS, INC.

Size A4
Number 2-913SSTA H/S BLOCK
Rev 1

Date Fri Feb 27 1998
Filename SST-HSBLOCK.sch
Drawn by BY ANGEL
Sheet 1 of 1


D

C

B

A

A B C D

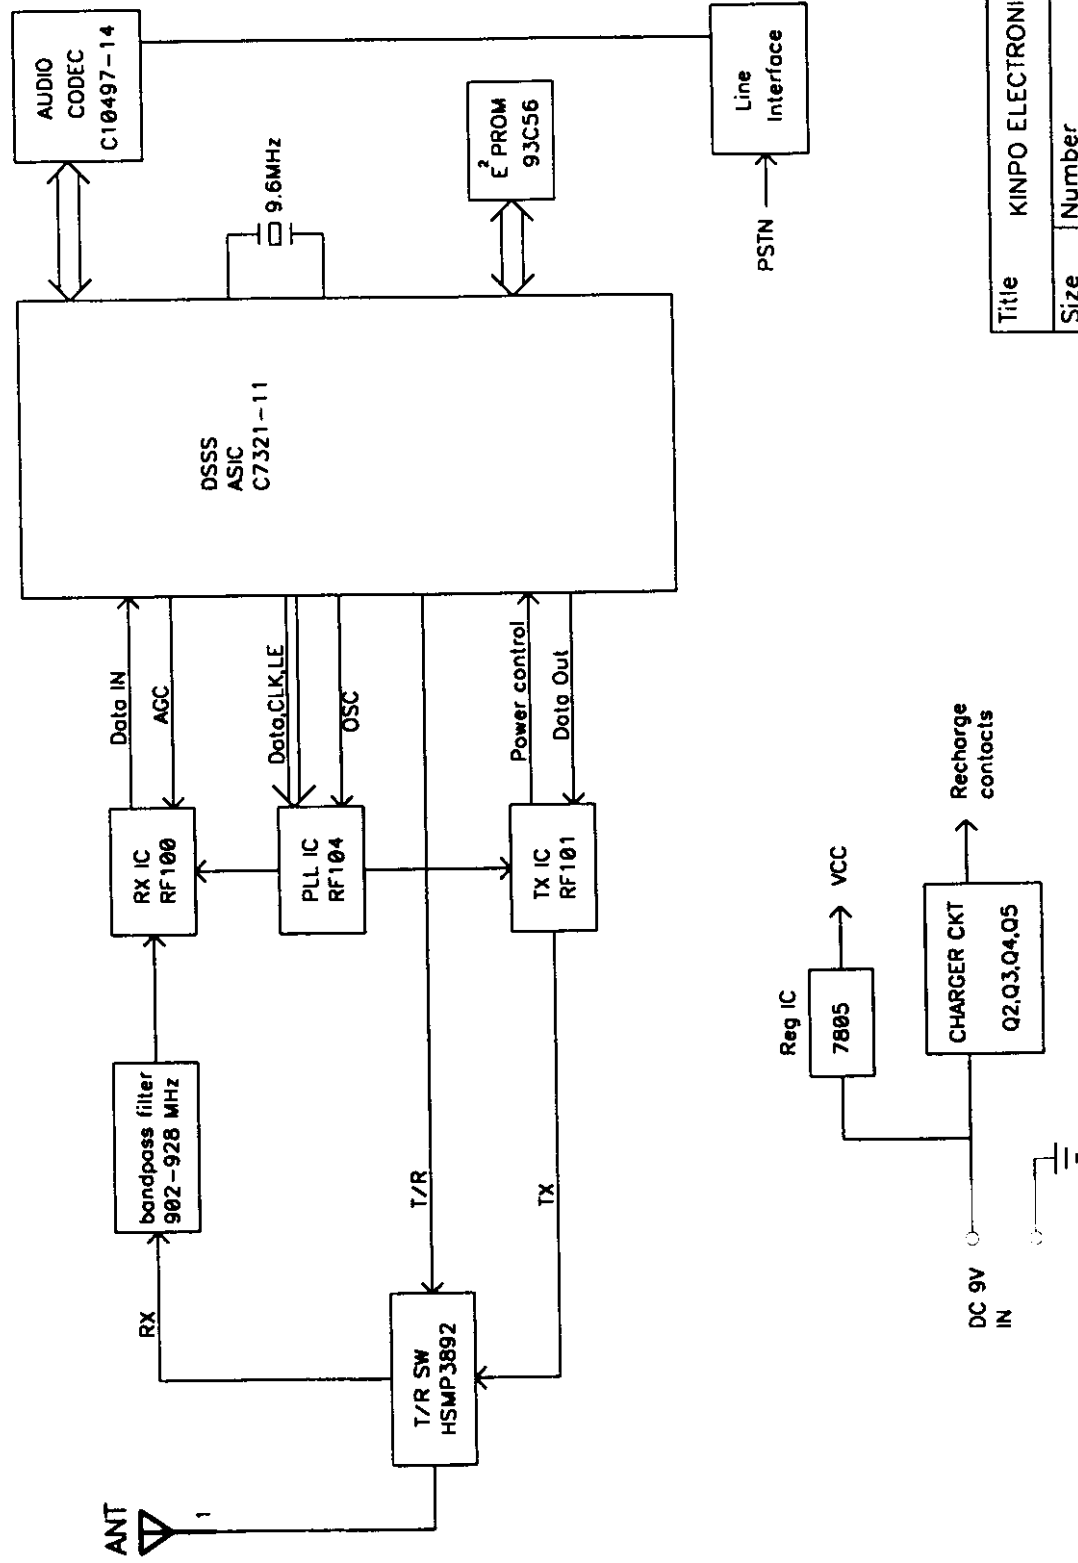


Title KINPO ELECTRONICS, INC.			
Size	Number	Rev	
A4	2-913SSTA B/S BLOCK	1	
Date	Fri Feb 27 1998	Drawn by BY ANGEL	
Filename	SST-BSBLOCK.sch	Sheet	1 of 1


A B C D

EXHIBIT F

Block Diagram

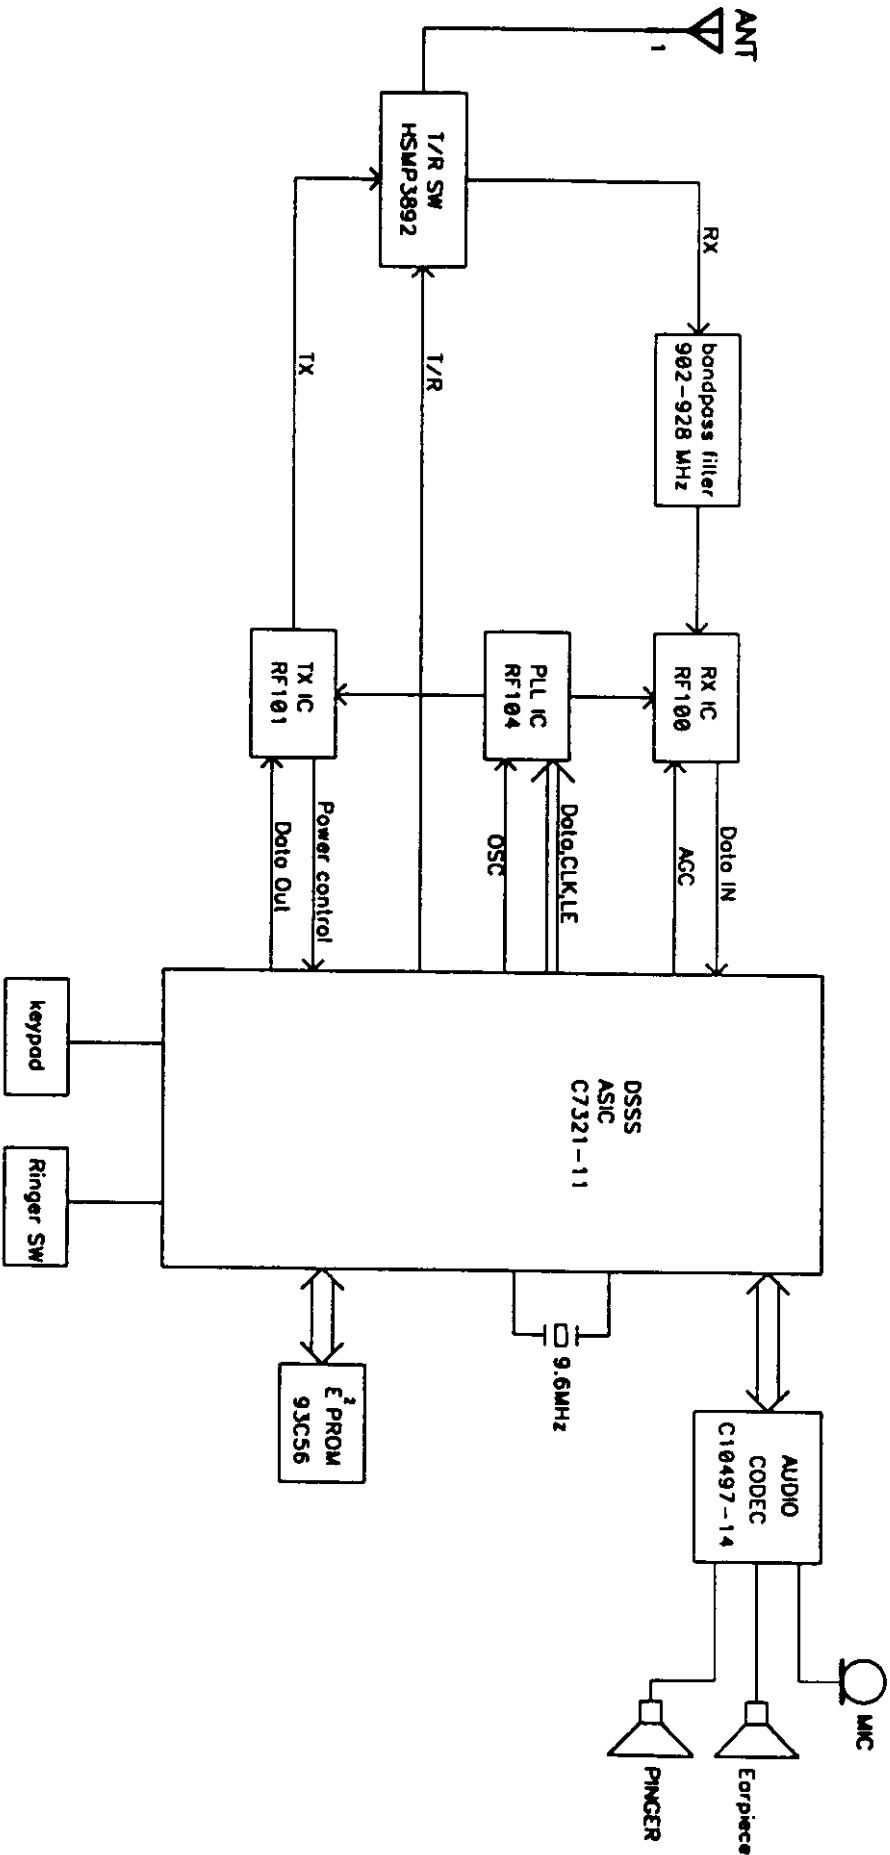

Title		KINPO ELECTRONICS, INC.	
Size	Number	2-913SS1A H/S BLOCK	
A4			
Date	Fri Feb 27 1998	Drawn by BR	
Filename	SSI-HSBLOCK.sch	Sheet 1 of	

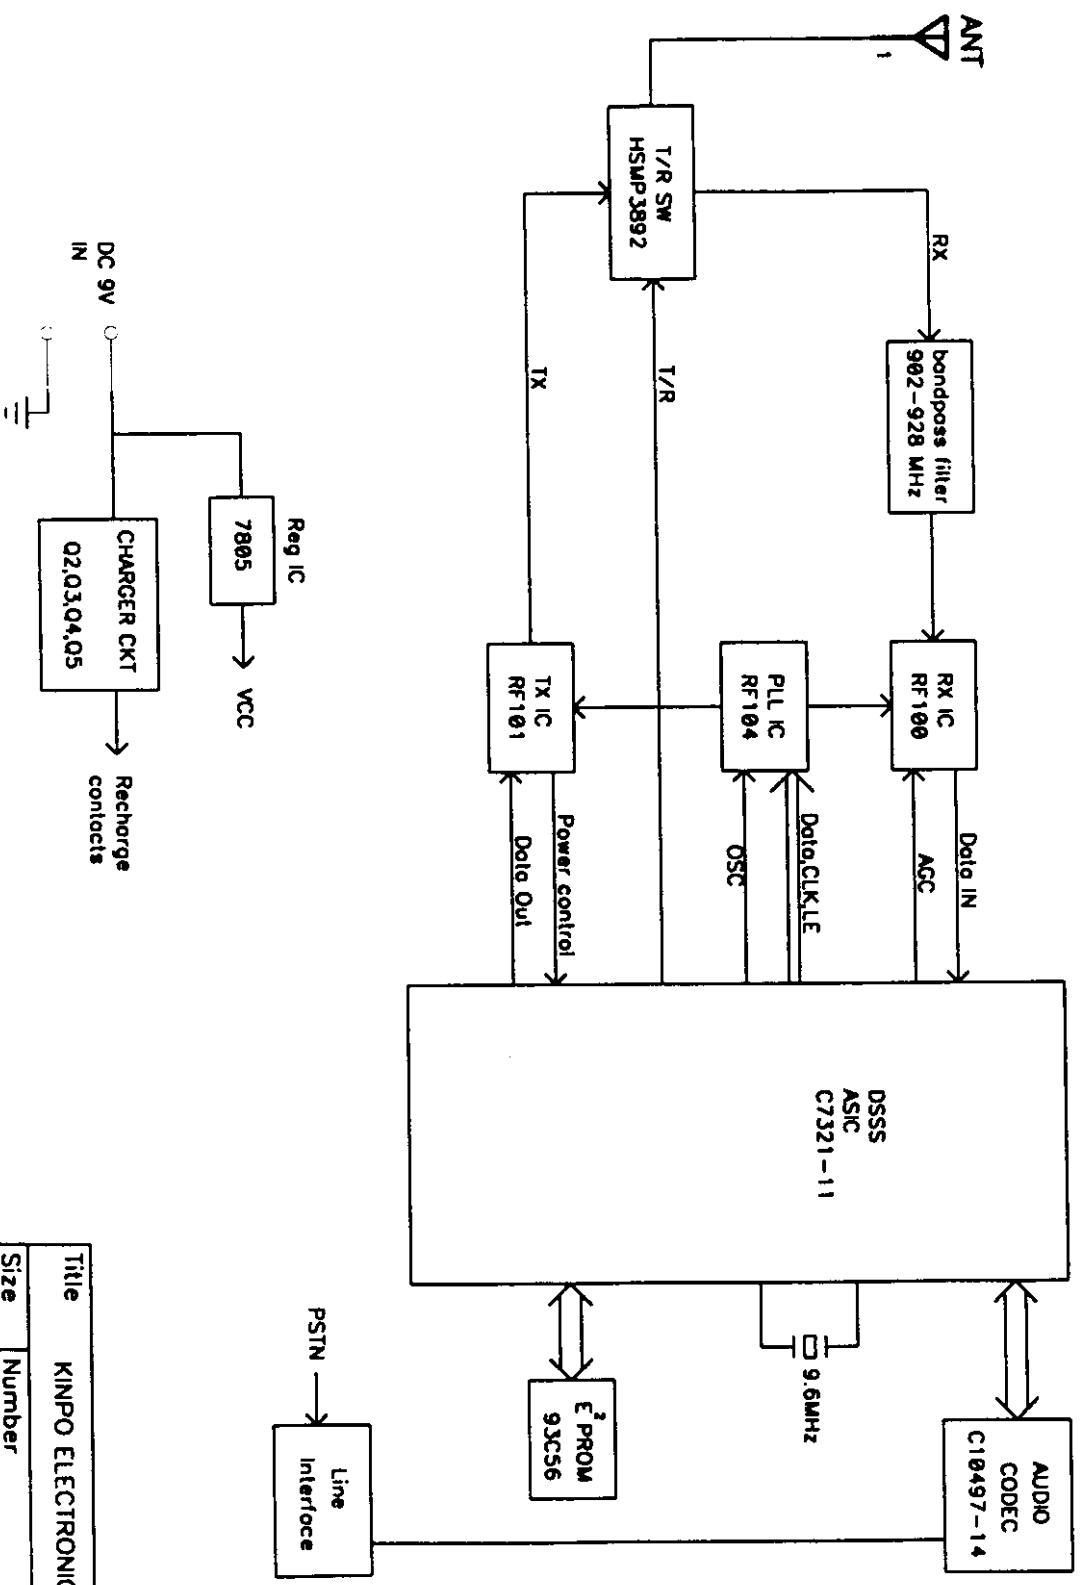

Title		KINPO ELECTRONICS, INC.	
Size	Number	2-913SS1A B/S BLOCK	
A4			
Date	Fri Feb 27 1998	Drawn by giv	
Filename	SSI-BSBLOCK.sch	Sheet 1 of	