


MCT-423 schematic diagram

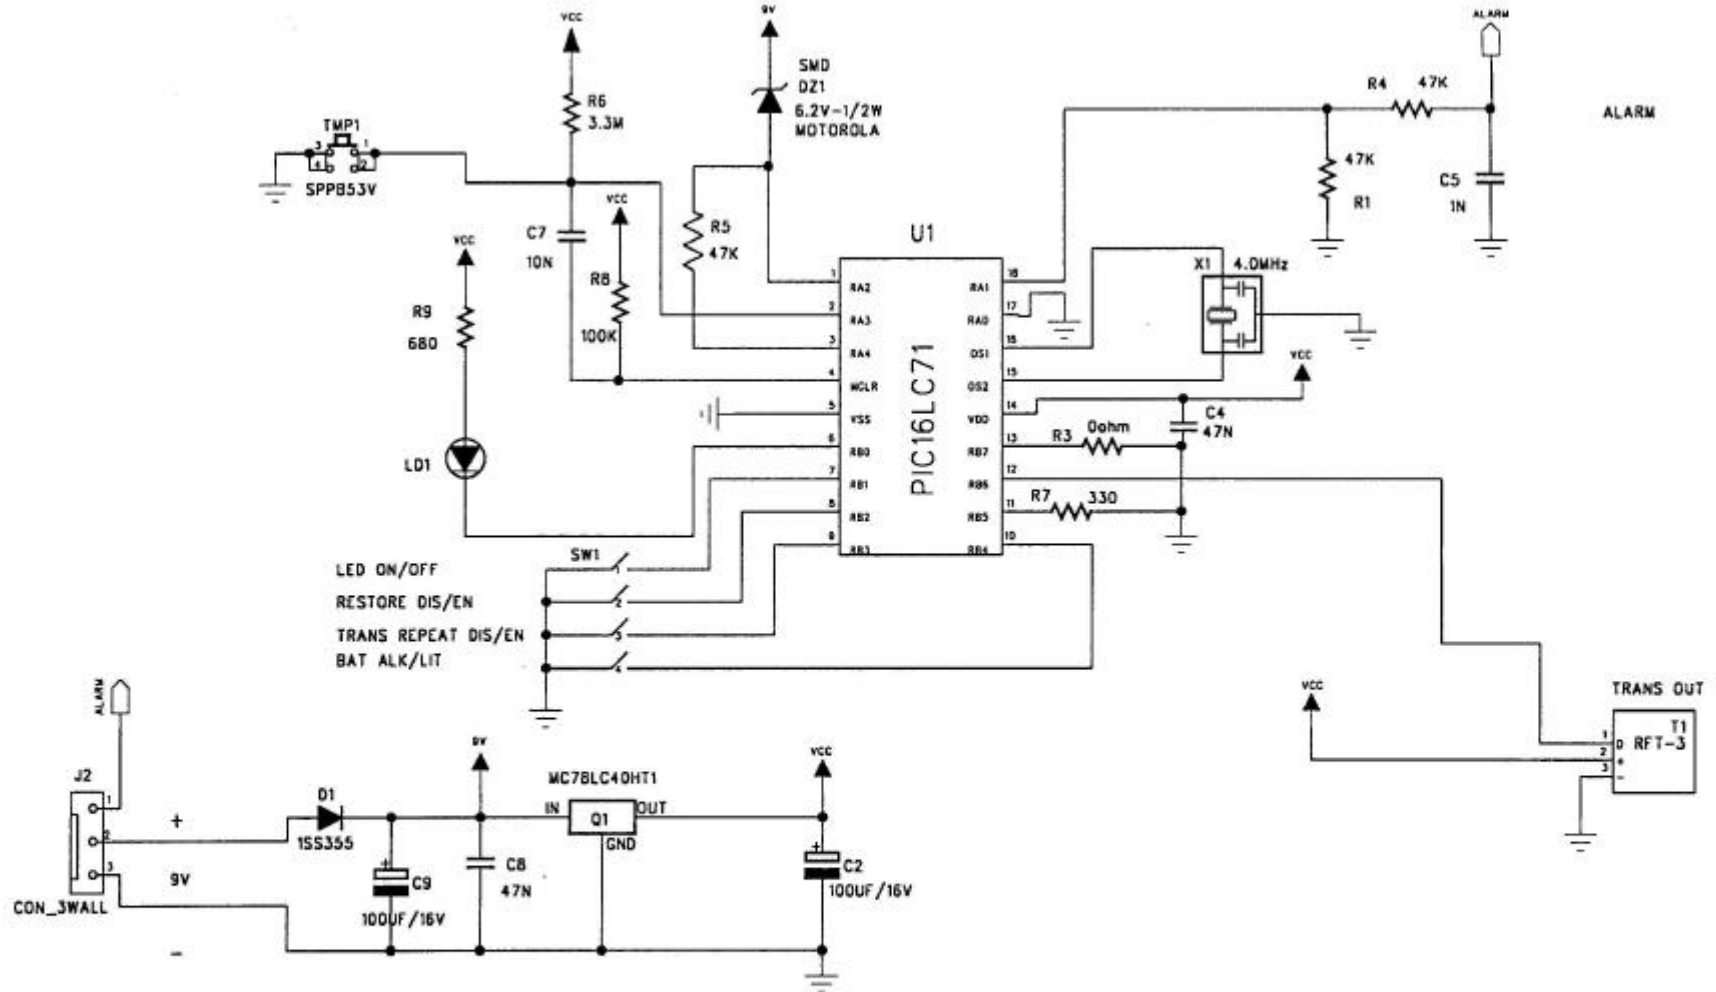

CONFIDENTIAL

This document contains information which is proprietary to Visonic Ltd. Israel. The use, copy or dissemination of this material for any purpose other than that which it is intended, is prohibited without the prior written consent of Visonic Ltd.

Date Released: to whom:



APX.2-1-3	NAME	DATE
DESIGNED	BAABI. P	12/07/99
DREW	SARI T.	12/08/99
CHECKED		
UPDATED		
APPROVED	BAABI P.	

PRODUCT NAME: MCT-423

DRAWING TYPE: SCHEMATIC DIAGRAM

PCB Rev:A DDC Rev:0

CATALOG NO: E-3640-0

DRAWING NO: EE-3640-1

CAD FILE: E3540_A.SCH

SHEET #/OF: 1 / 1

LPD

;

2

	3	
--	---	--

--	--	--

	5	
--	---	--

	6	
--	---	--