




1. This diagram is a floor plan schematic for a building, likely a school or office, showing room layouts, furniture, and electrical symbols. The plan is enclosed in a dashed border. Key features include:

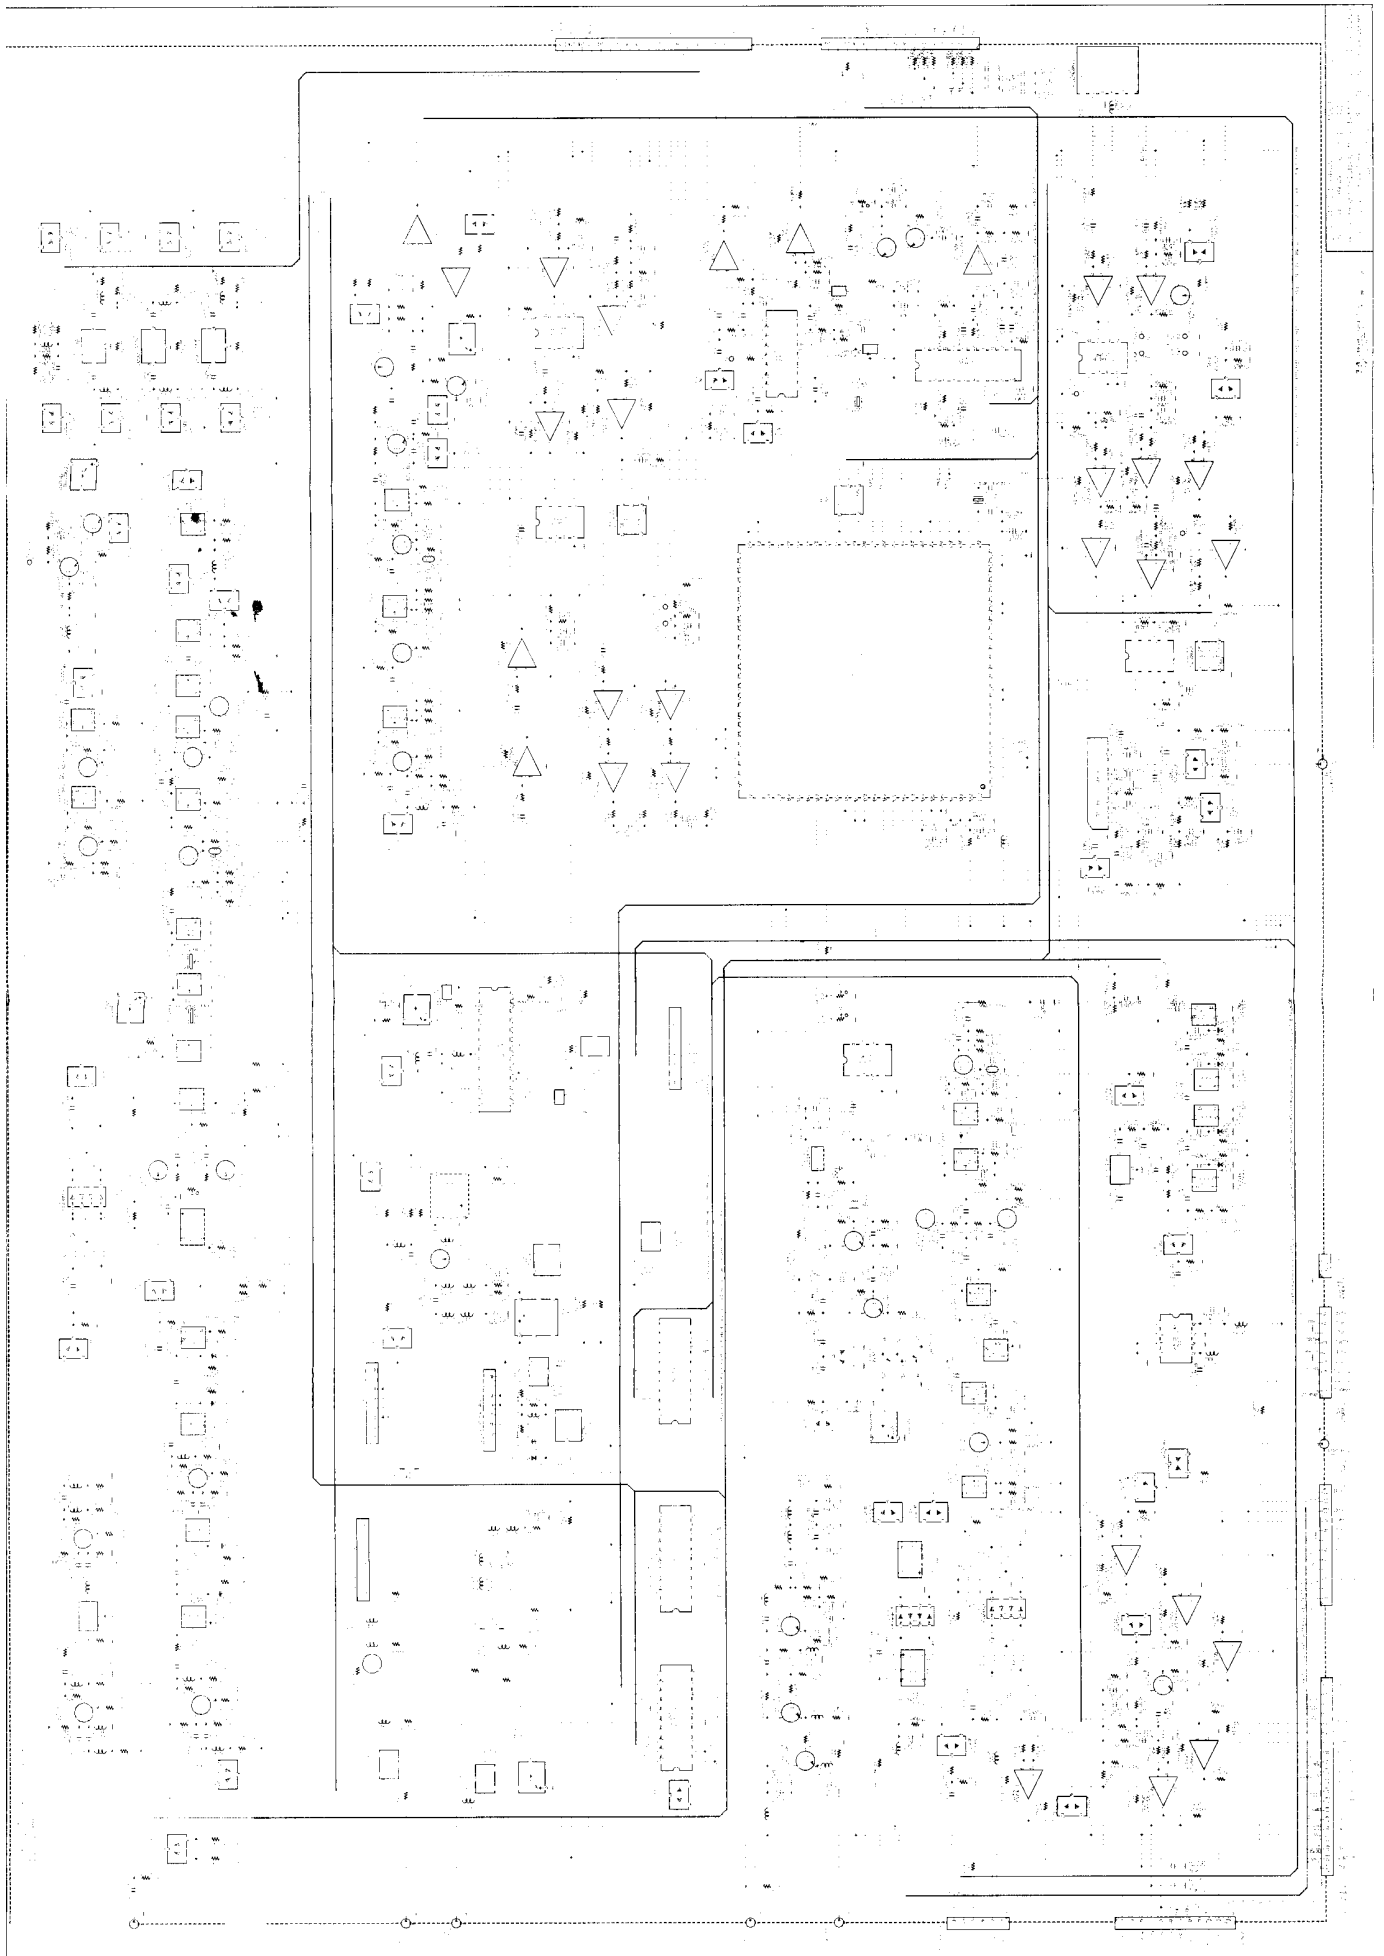

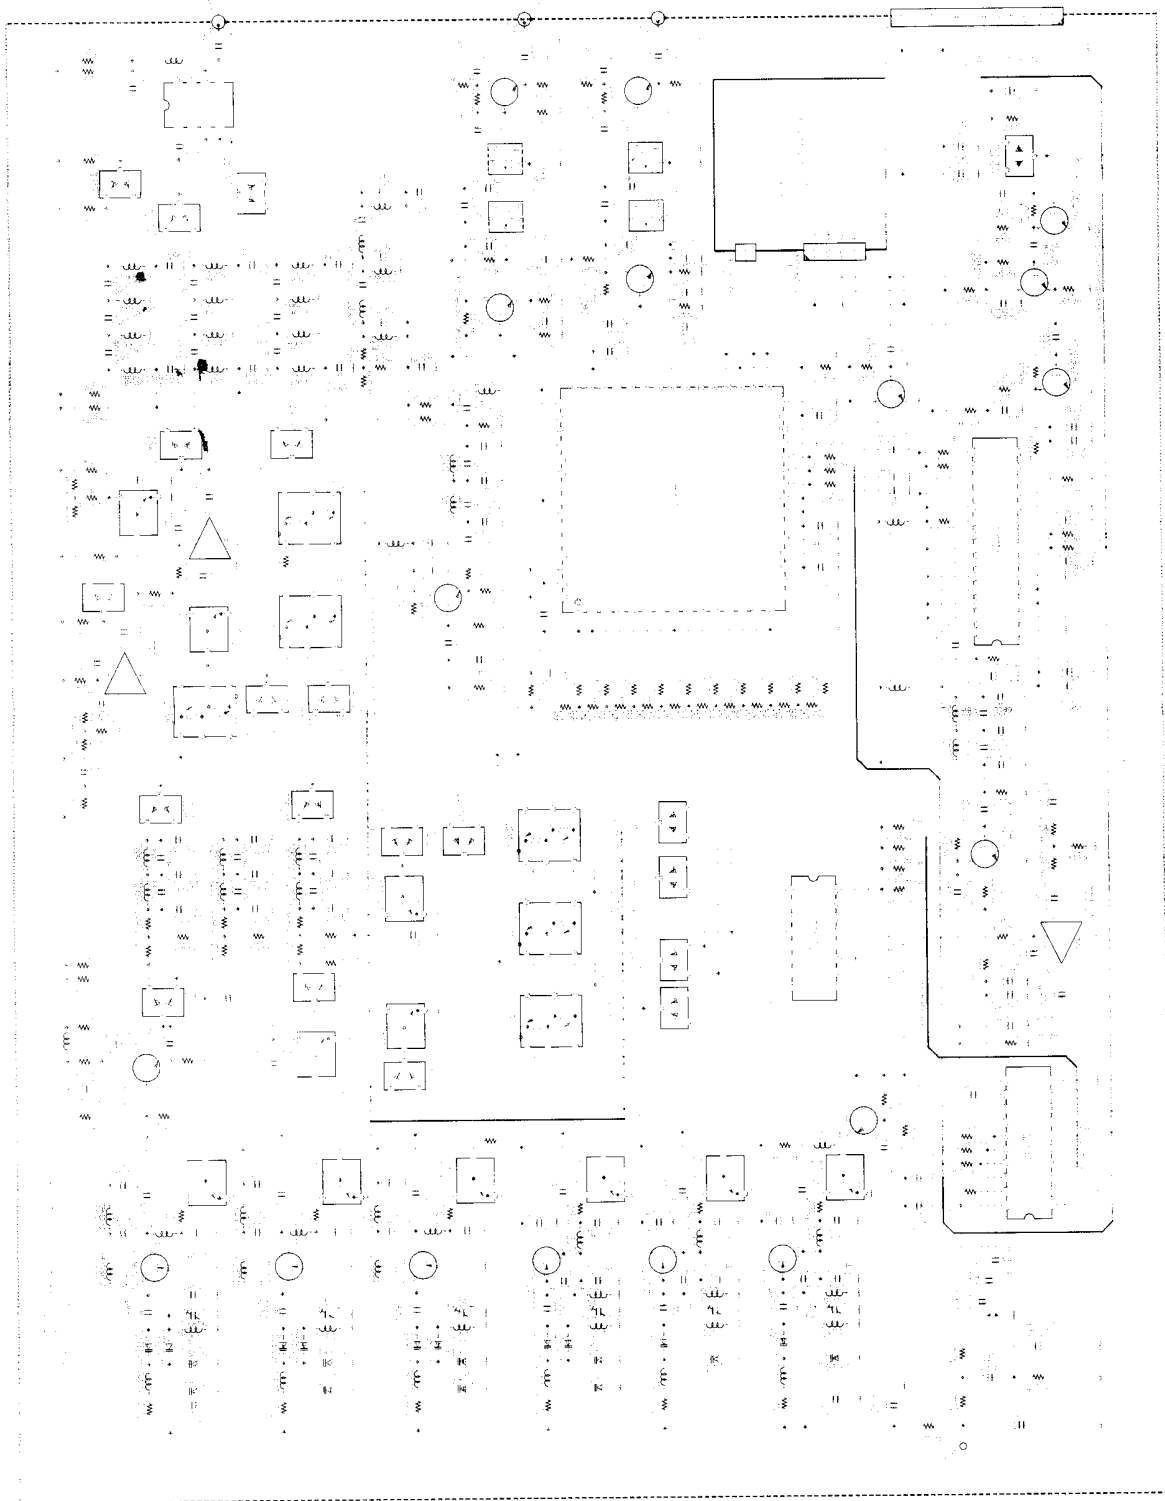


Technical drawing of a mechanical assembly, possibly a motor or generator, showing various components and wiring.

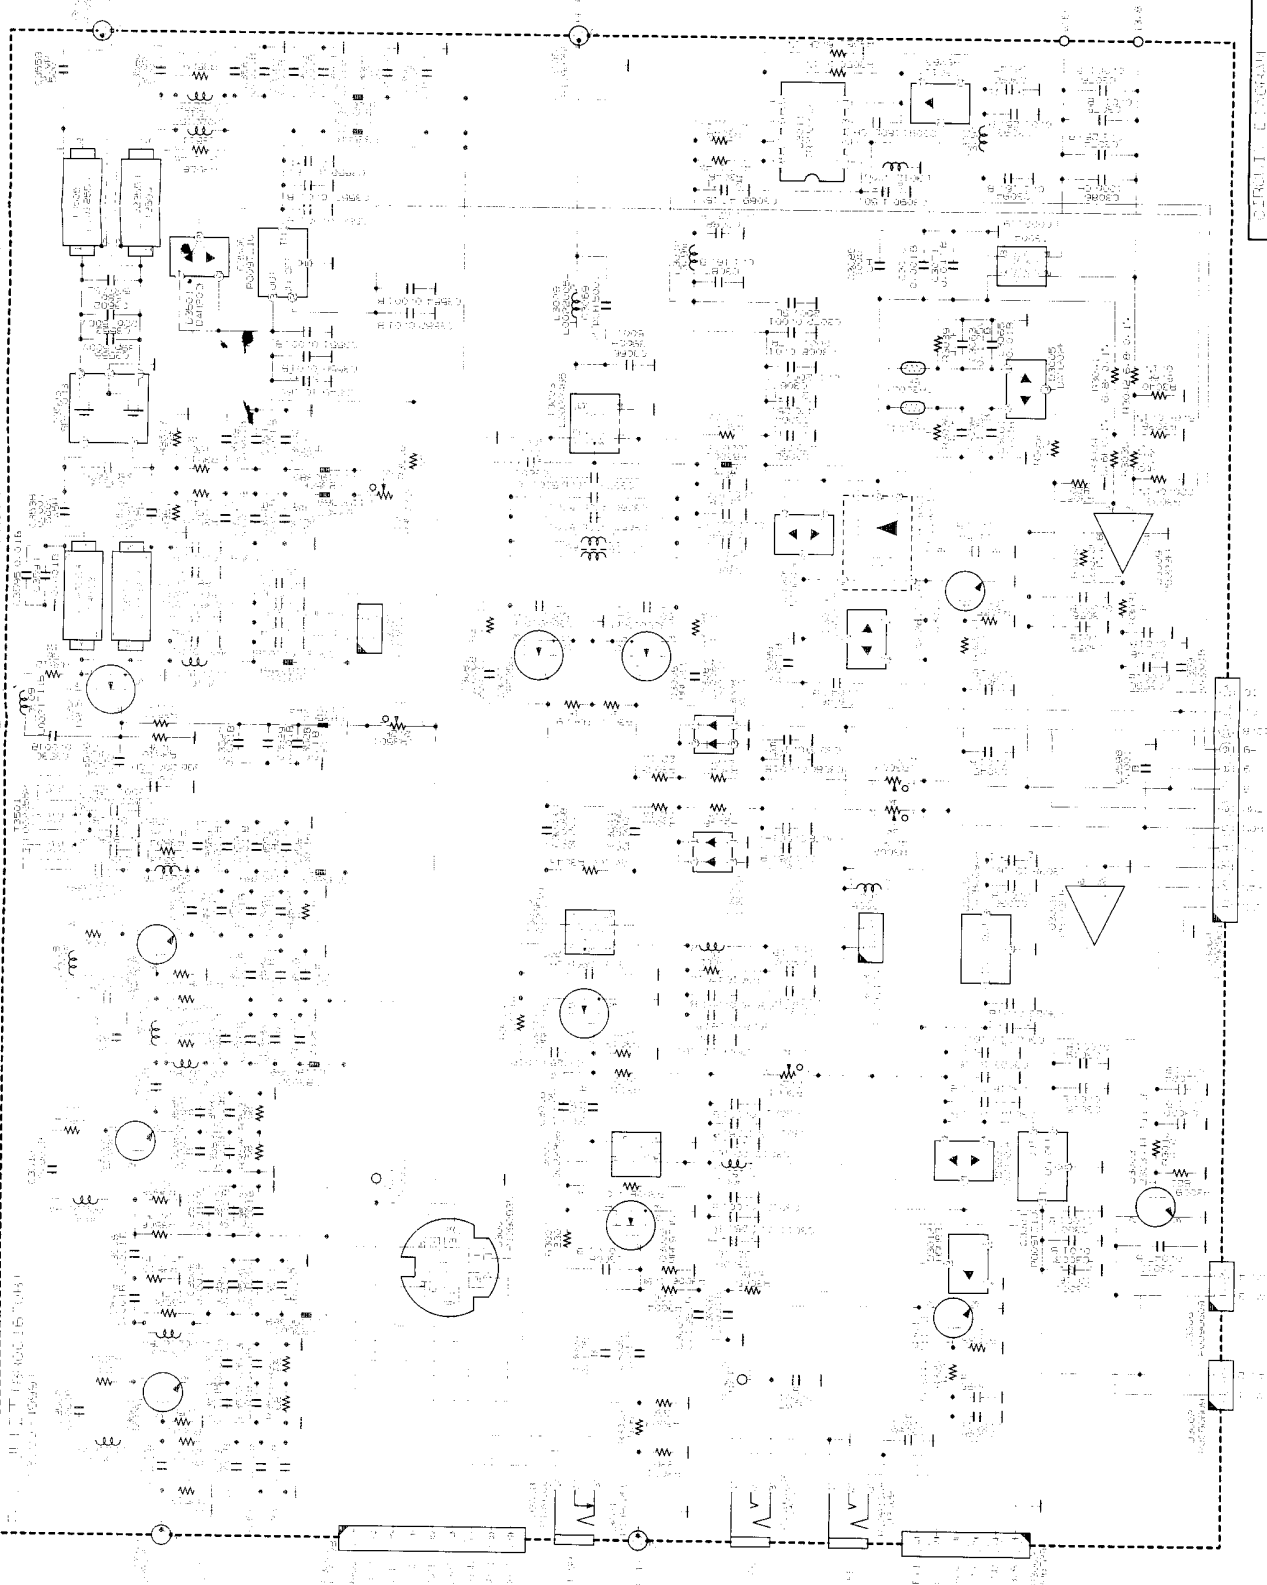


PROGRAM NAME: PT 100
 DESIGNED BY: DJT
 REC'D BY: [Signature]
 DATE: [Date]
 [Other administrative markings]

11-11-15-10451
 10/25/91

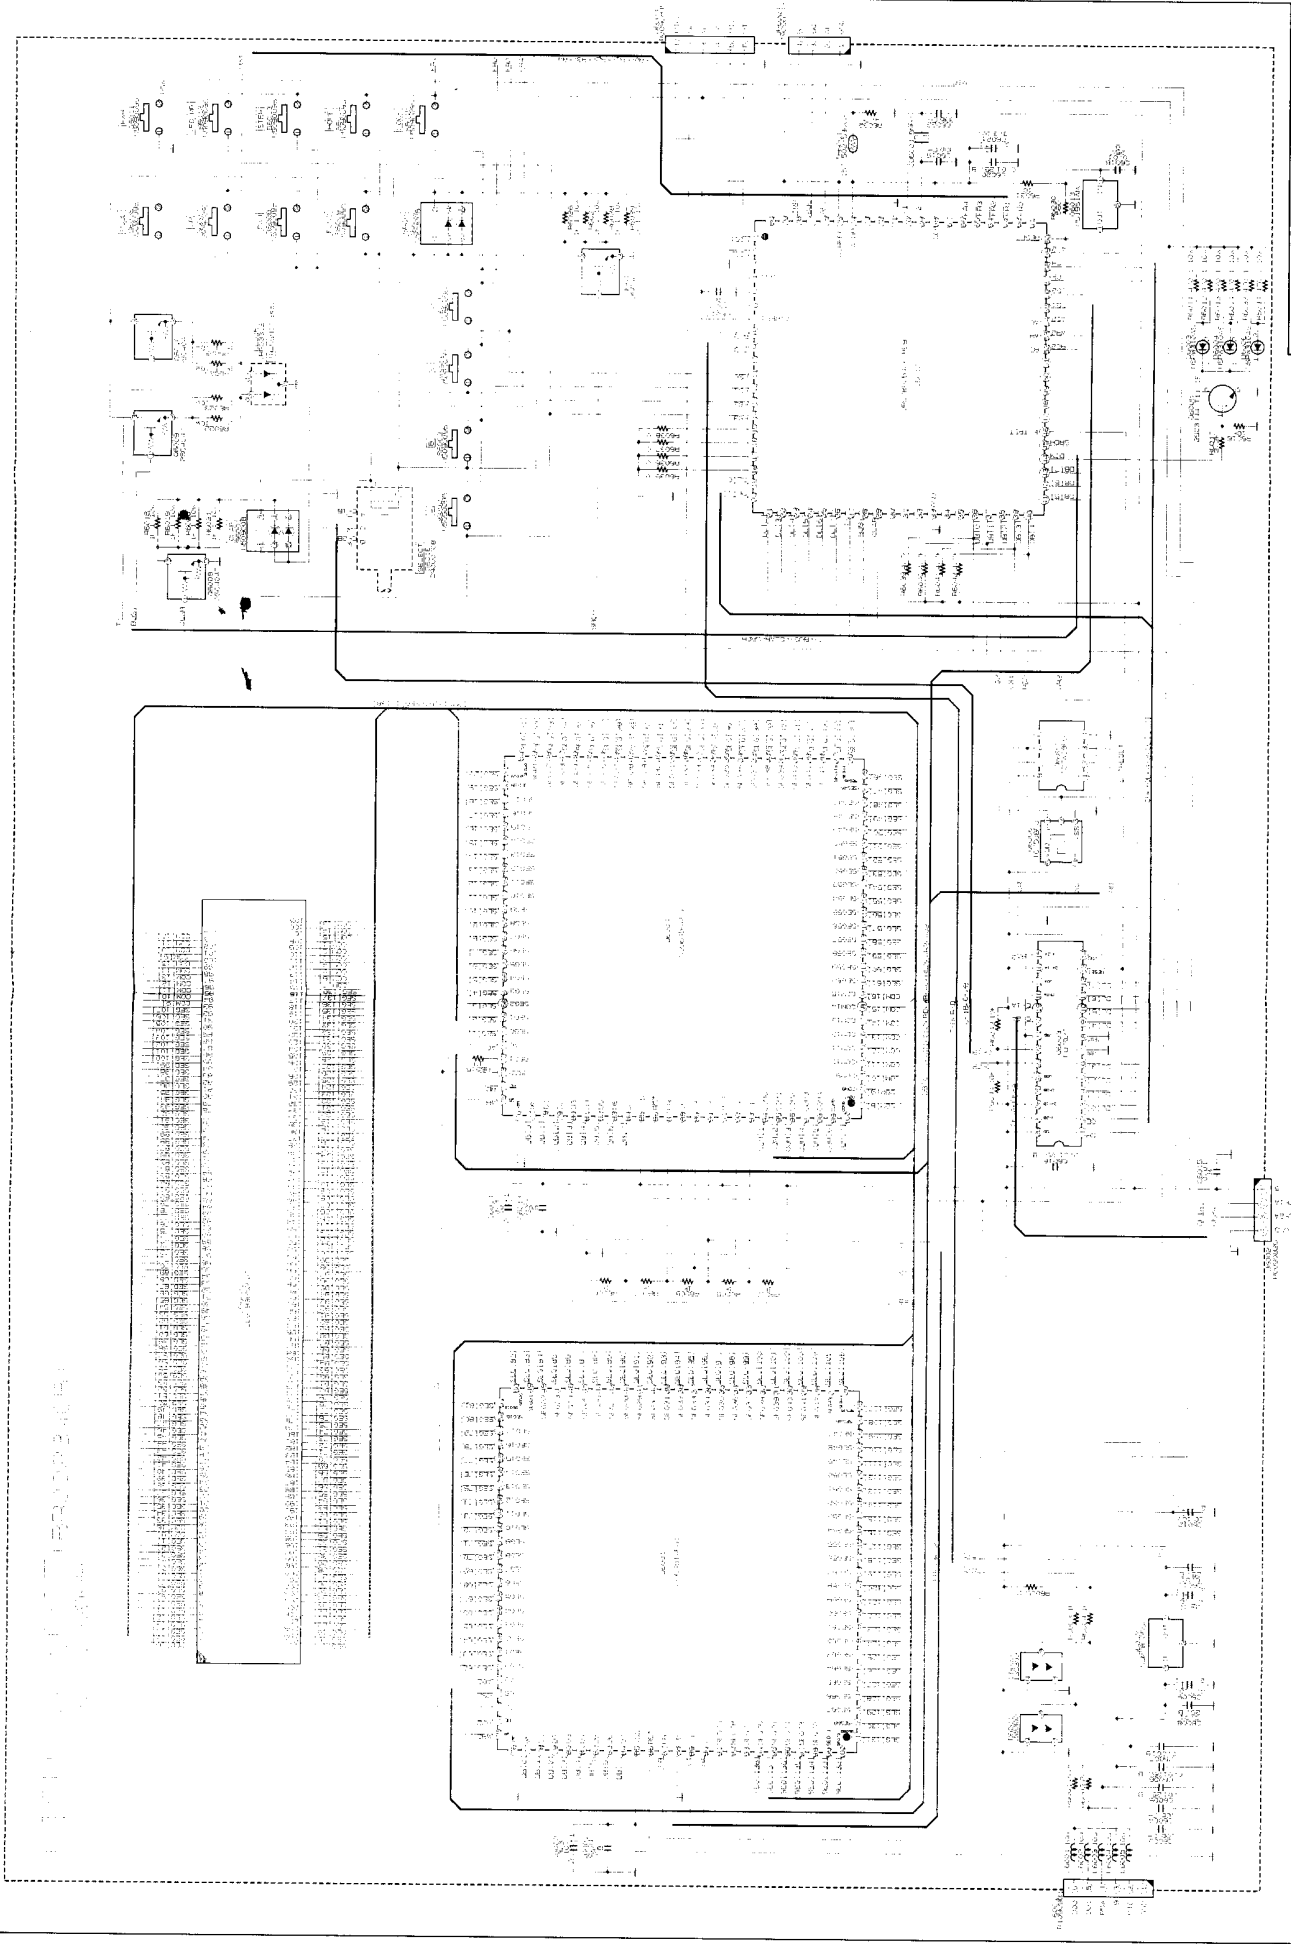


DRAWN BY: [Name]
 CHECKED BY: [Name]
 DESIGNED BY: [Name]
 DATE: [Date]
 PROJECT: [Project Name]

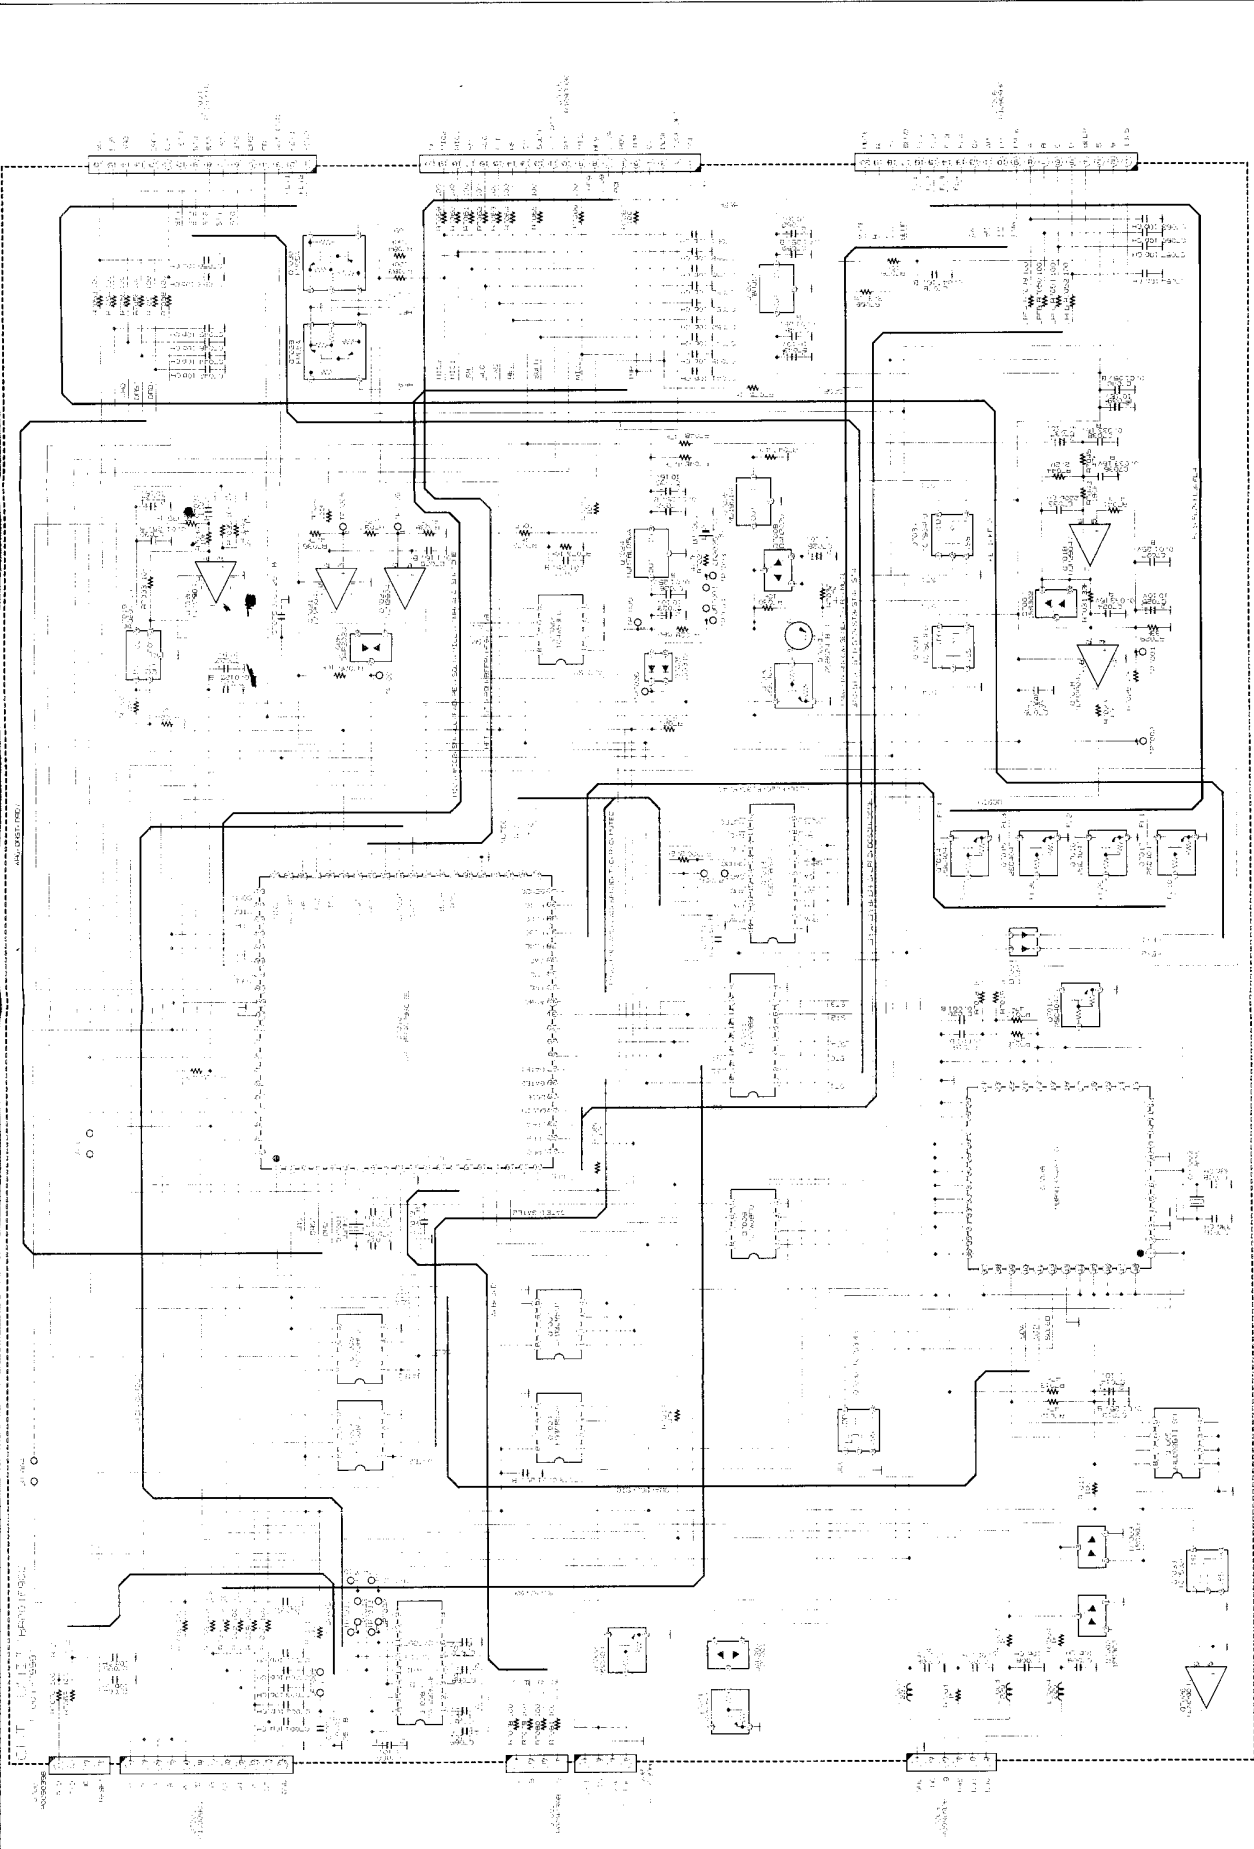


MODEL: 11-100
CIRCUIT BOARD UNIT
DEF: BOSTON 11-100
UNIT: 11-100-100
REVISION: 100


11-100-100-100

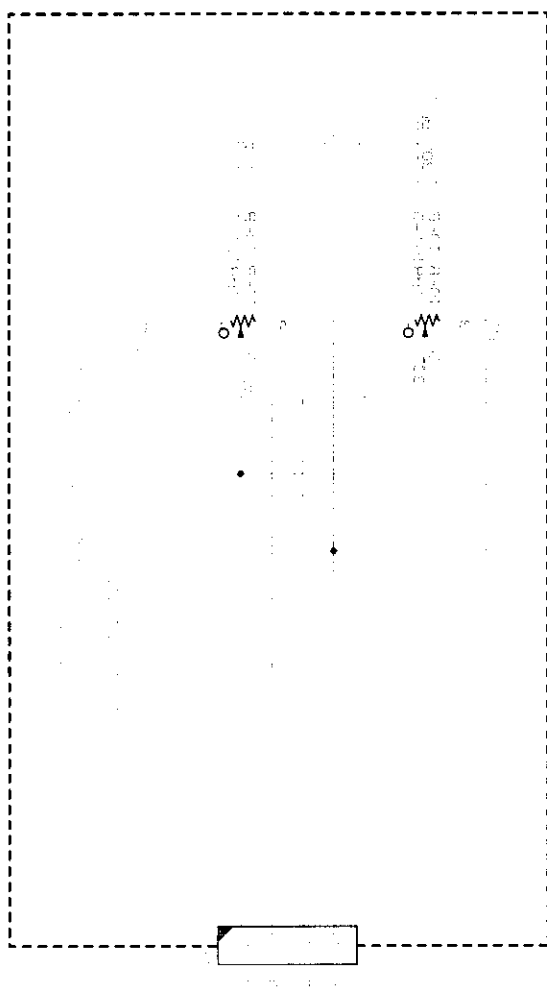


CATALOG GENERAL MODEL 577-00
 DIS. 3-10896909 REV. 11/11
 REF. EP1008703.01 001. SOL ED. 10/10/00
 DATT. 2-10-1997 UDCITE 4. VAR. 1992
 PIESO RUSSETI CO., LTD

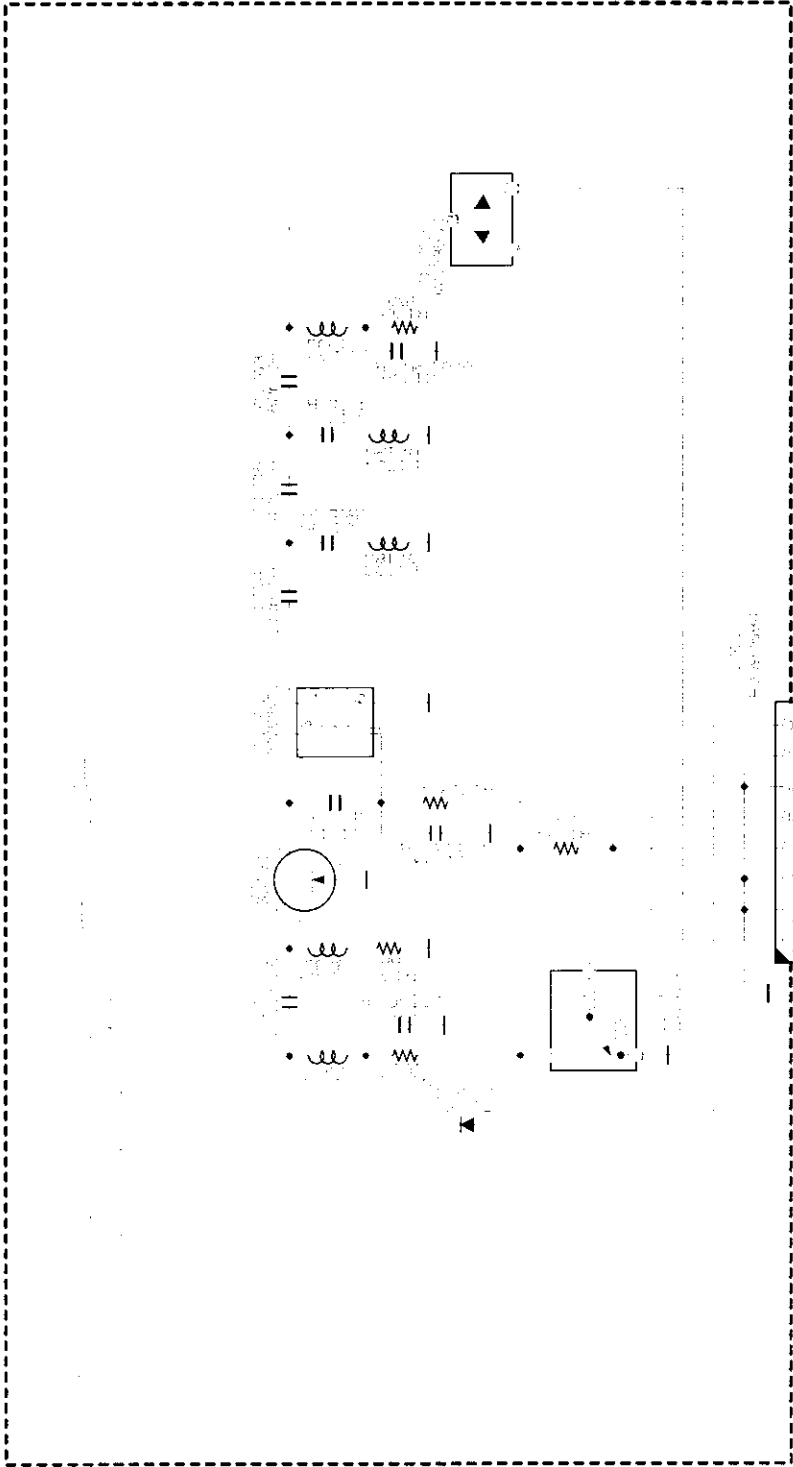

CTRC 11 0123RPH MODEL FT-100
 DES. R.02090000 BHFIL-UNIT
 REF. BPS02020B.CIR 001.SHT EDITION 0000
 DATE 12.03.1997 UPDATE 17.MAR.1998
 CABLES USE: COLLEO

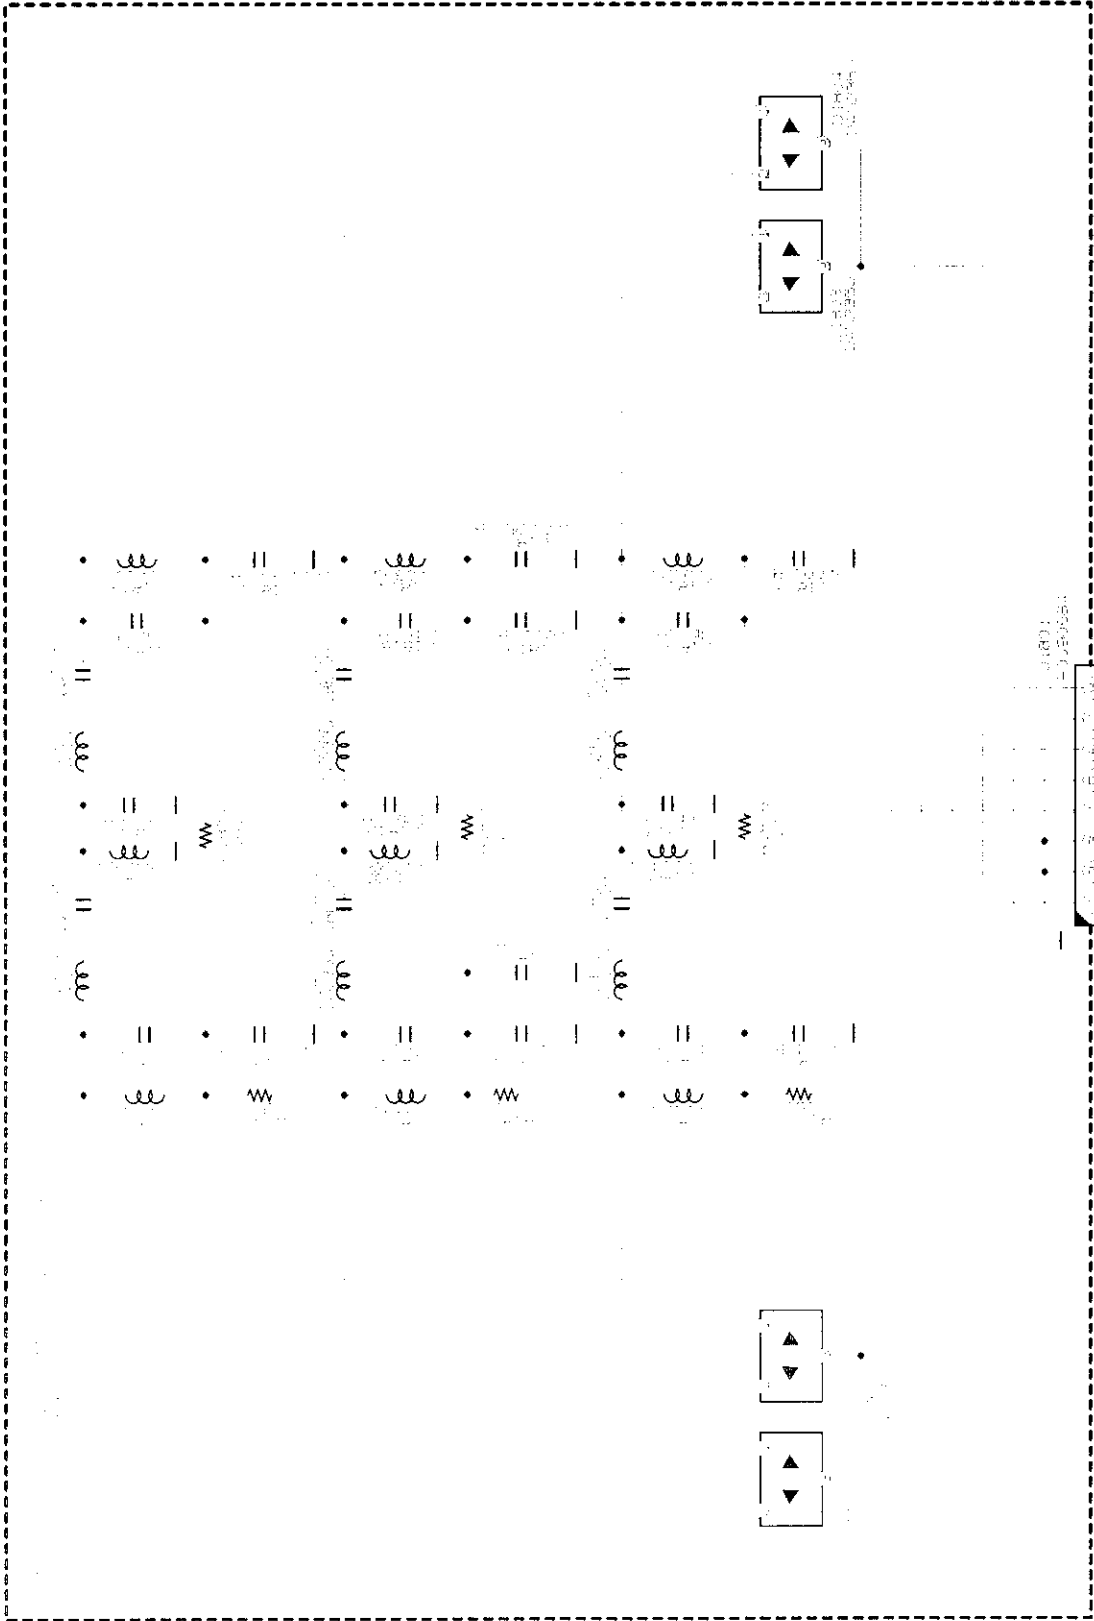


DATE	10/11/1996	CHD/E	11/18/1996
BY	10/11/1996	CHD/E	11/18/1996
NO.	10/11/1996	CHD/E	11/18/1996
REV.	10/11/1996	CHD/E	11/18/1996

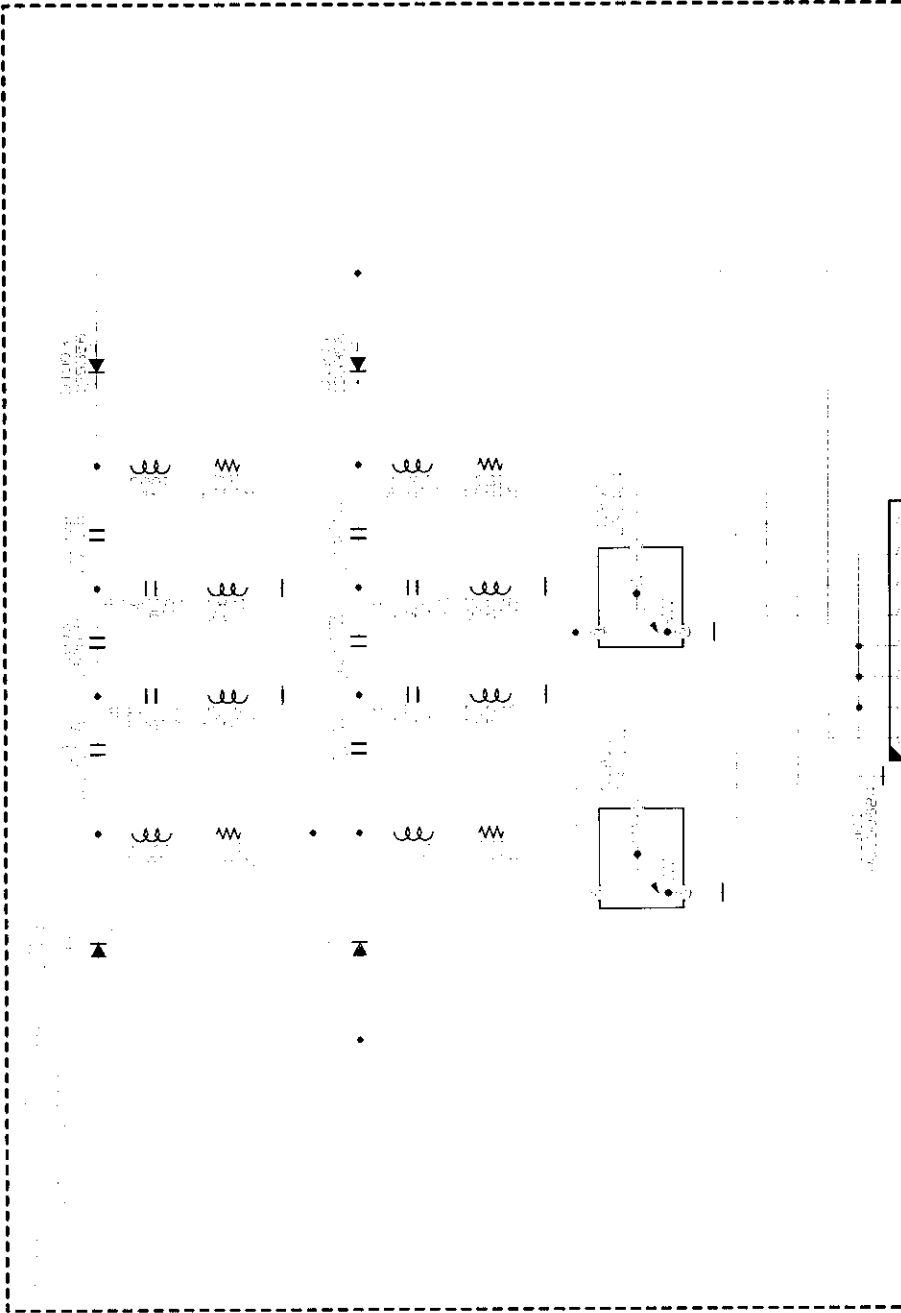


1	1.00
2	1.00
3	1.00
4	1.00
5	1.00
6	1.00
7	1.00
8	1.00
9	1.00
10	1.00
11	1.00
12	1.00
13	1.00
14	1.00
15	1.00
16	1.00
17	1.00
18	1.00
19	1.00
20	1.00
21	1.00
22	1.00
23	1.00
24	1.00
25	1.00
26	1.00
27	1.00
28	1.00
29	1.00
30	1.00
31	1.00
32	1.00
33	1.00
34	1.00
35	1.00
36	1.00
37	1.00
38	1.00
39	1.00
40	1.00
41	1.00
42	1.00
43	1.00
44	1.00
45	1.00
46	1.00
47	1.00
48	1.00
49	1.00
50	1.00


PROJECT NUMBER	MODEL NUMBER
REV. 8-20-99	REV. 1-1-99
REV. 8-20-99	REV. 1-1-99
DATE 8-20-99	DATE 1-1-99
DESIGNER	DESIGNER
APPROVER	APPROVER

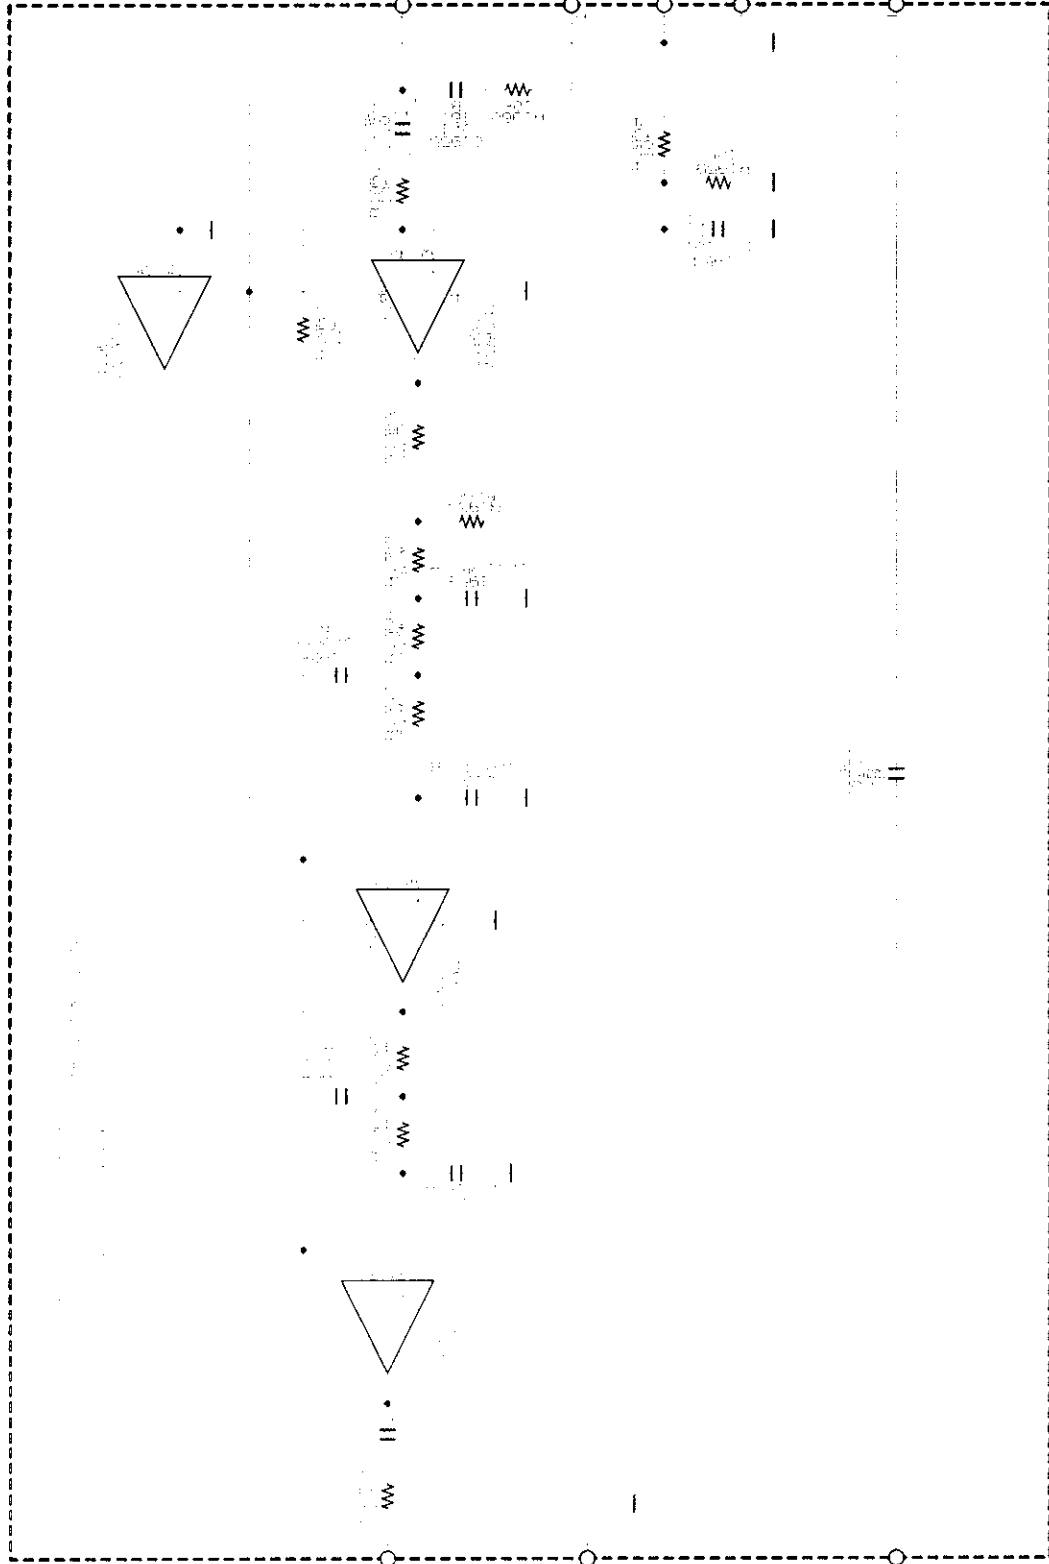

CIRCUIT DIAGRAM MODEL FT-100
DES. B-38860000 AUDIC-FI UNIT
REF. B-38860000 IN COLLISION EDITED
DATE 14 APR 1988 (PDC/F 14 APR 1988
AF507166F) (000000)
788600 1988 04 30 1010P

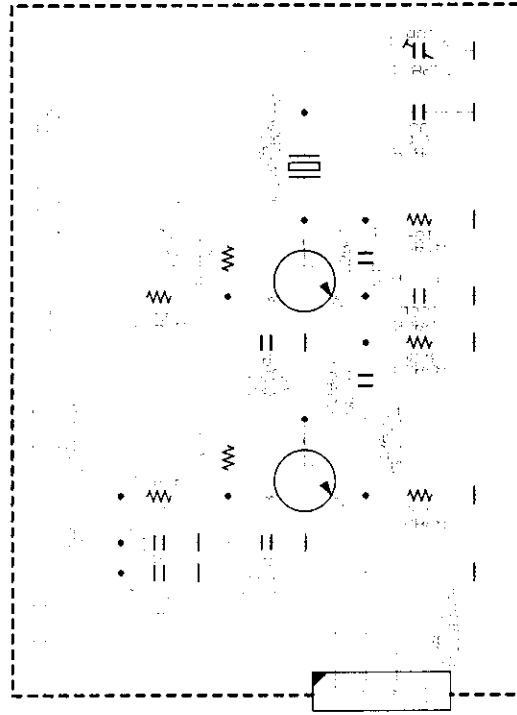

MODEL ET-100
 REF. 0-1000000 REF. 111
 REF. 800-1000-100-100-100-100
 DATE 30.08.1997 PULSE ELECTRONICS LTD
 AEBU HOUSE LTD

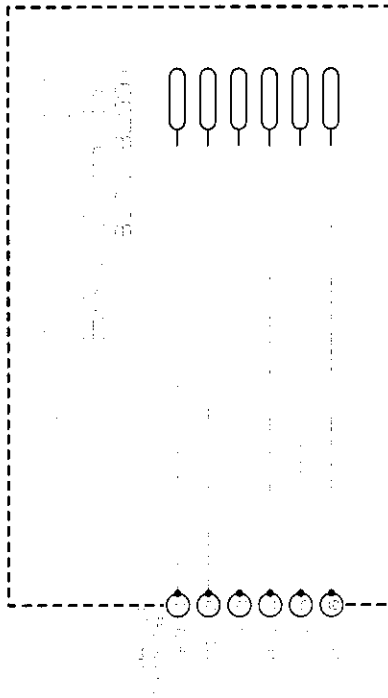

CIRCUIT DIAGRAM MODEL 87-100
 DESG B740890000 COLLECT-2-FULT
 REF: RPO008408.210.001.snt POTETOT.100E
 DATE 24.05.1999 UPDATE 14.10.1999
 AESU ROSETI CO., LTD